

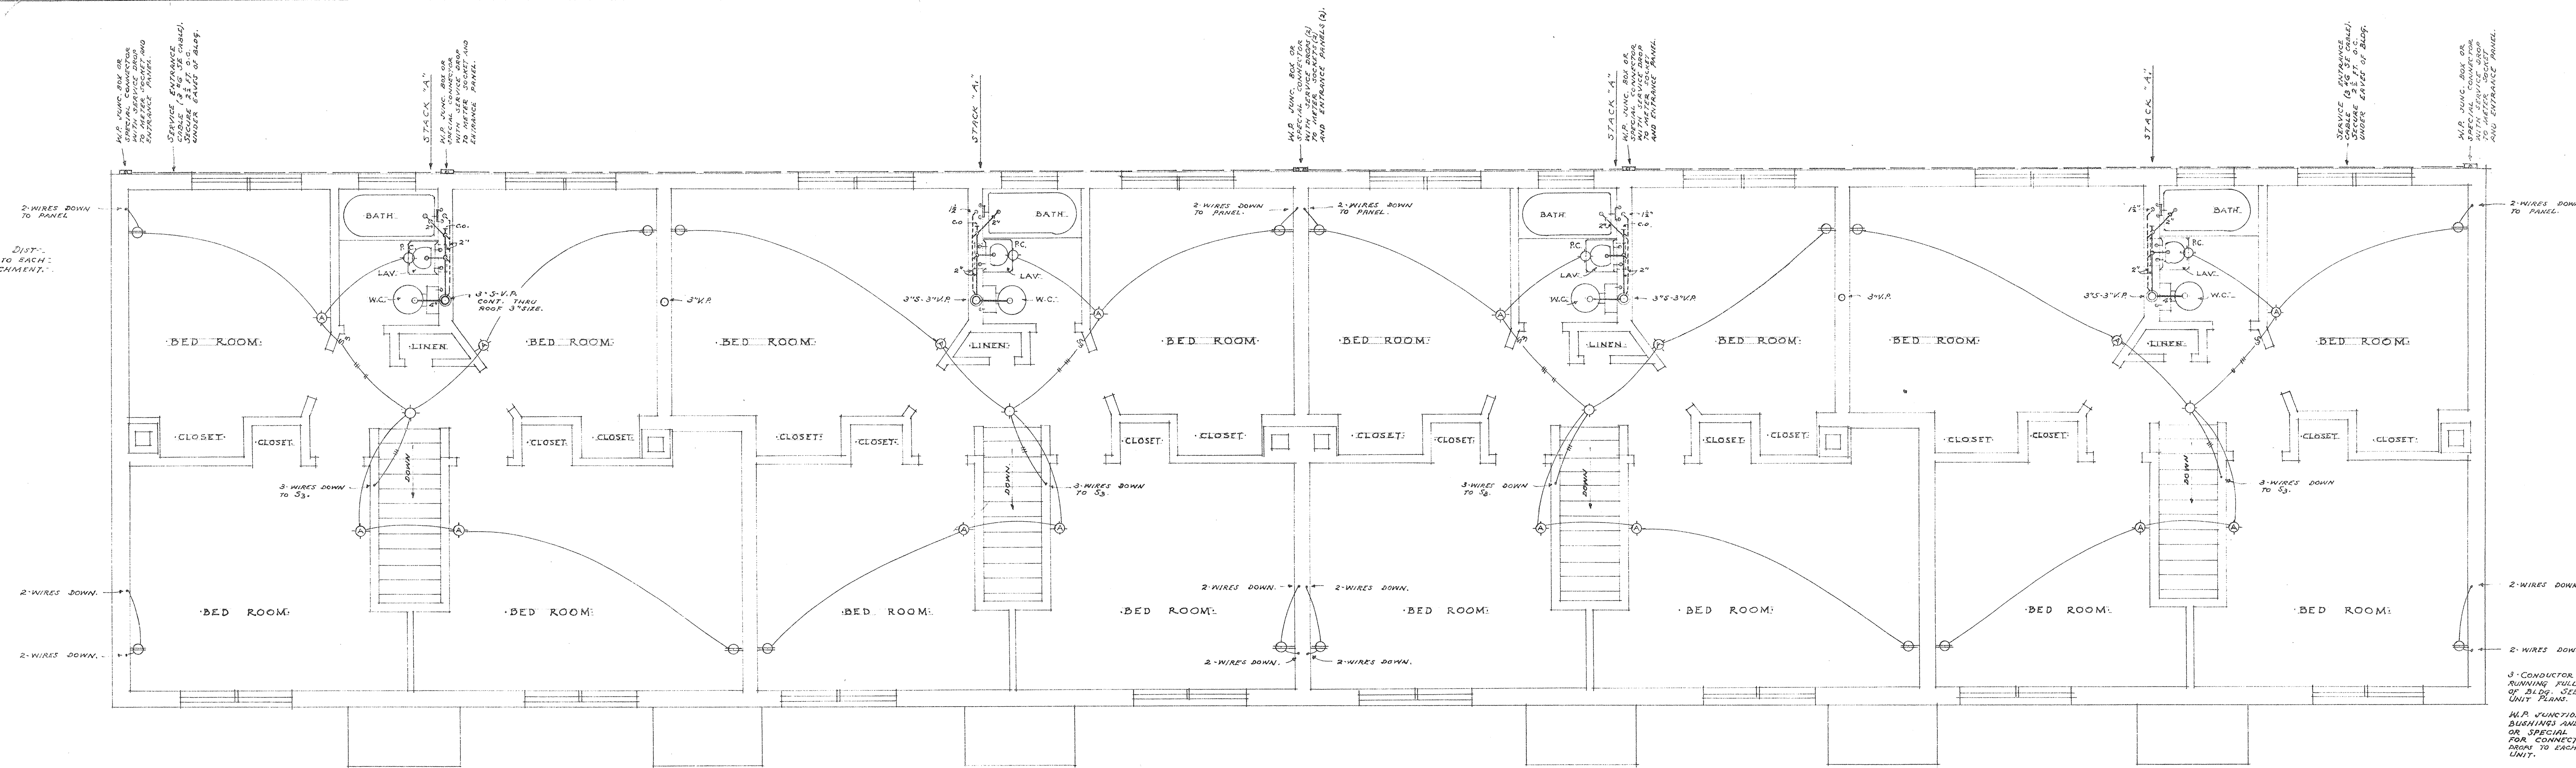


ELECTRICAL NOTE:
SEE SITE PLAN OF ELECTRICAL DIS-
TRIBUTION FOR SERVICE DROP TO EACH
BUILDING AND POINT OF ATTACHMENT.

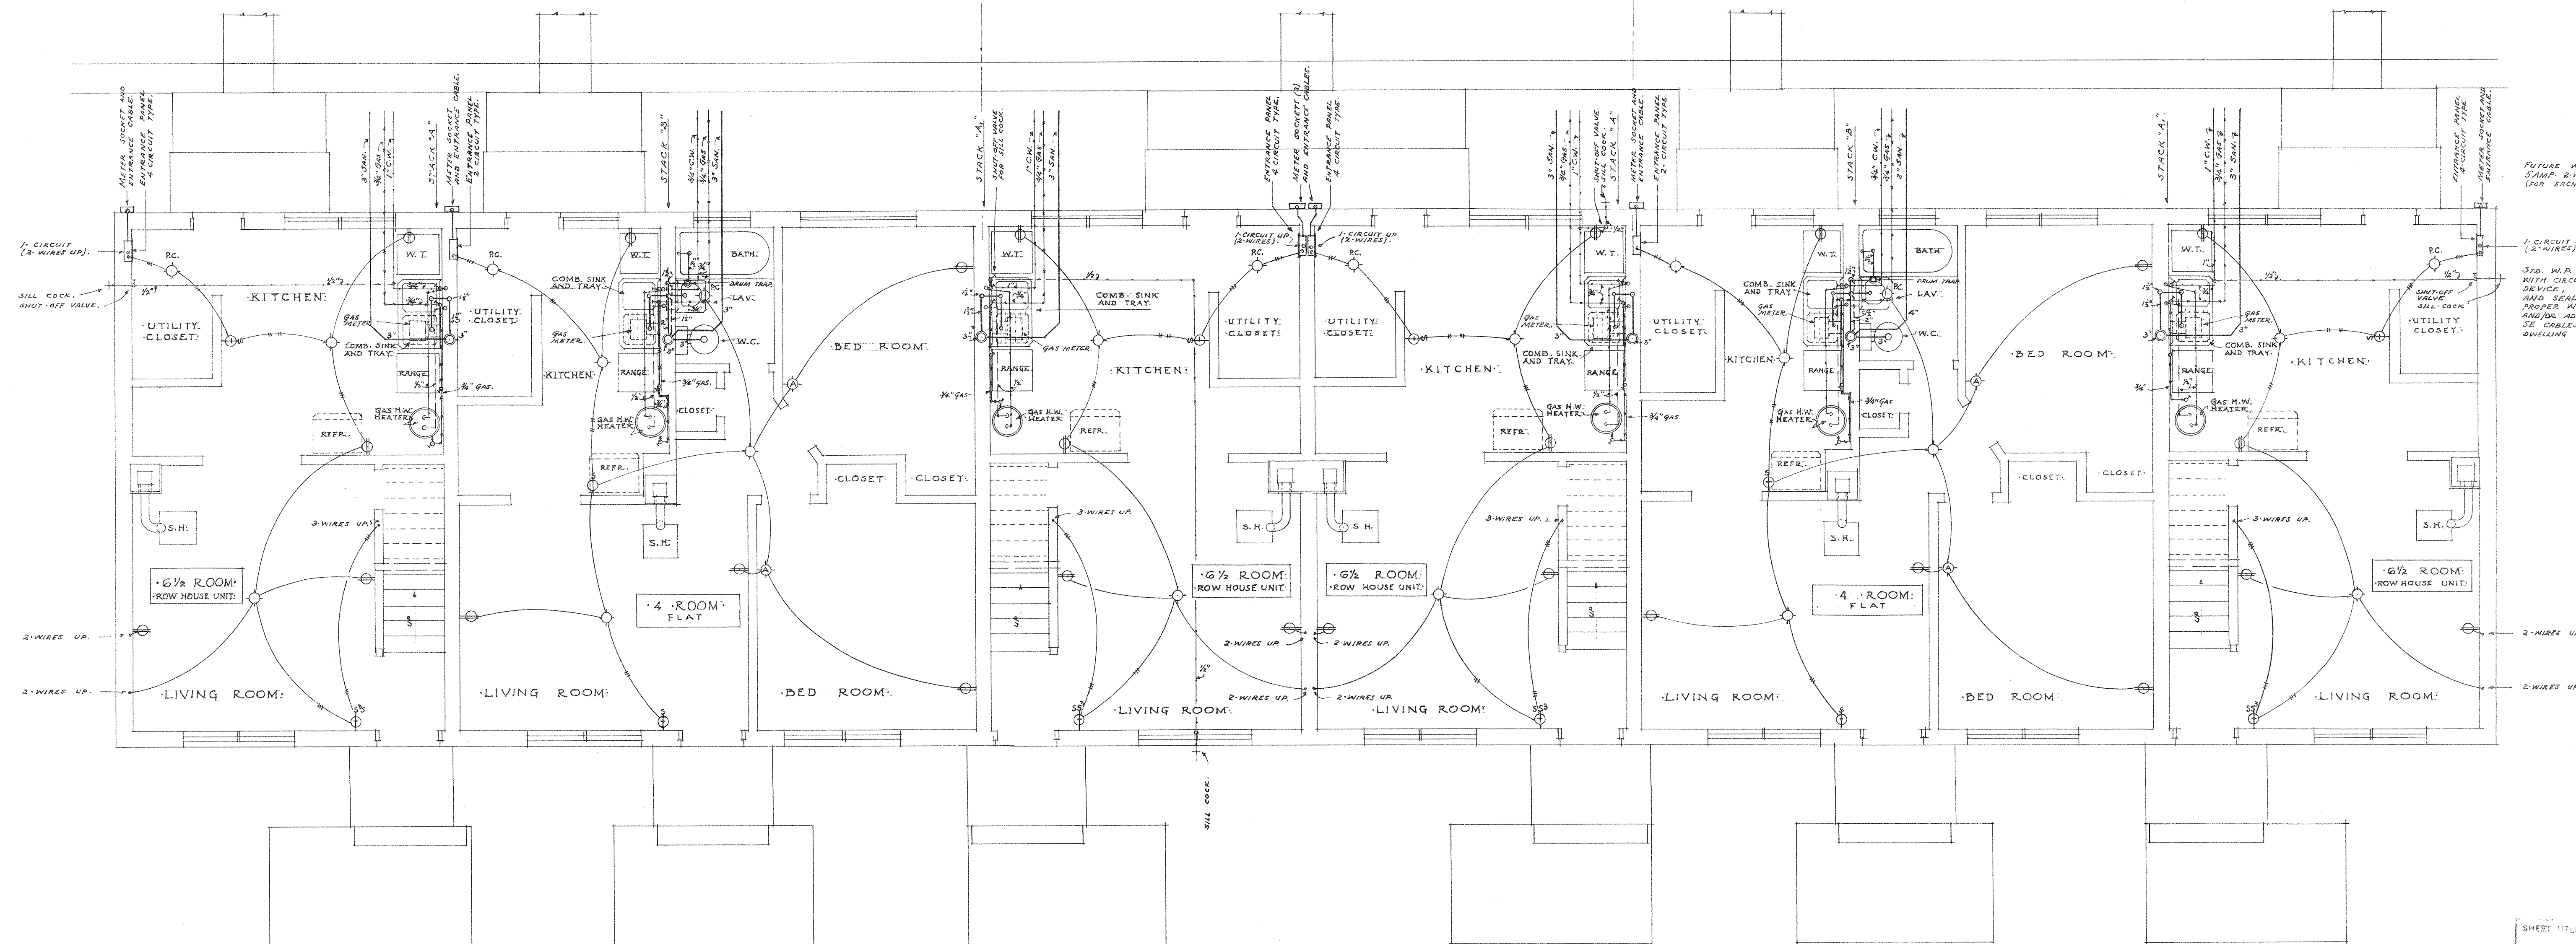

SECOND FLOOR PLAN

SCALE: 1/4" = 1'-0"

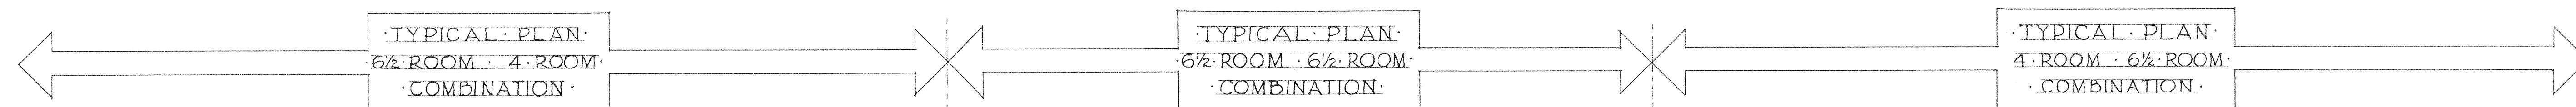

FIRST FLOOR PLAN

SCALE: 1/4" = 1'-0"

SCHEDULE OF FIXTURE CONNECTIONS

TYPE	H. W.	C. W.	TRAP	GAS	REMARKS
WATER CLOSETS		3/4"	INT.		
LAVATORIES	3/4"	3/4"	1/2"		
BATHS	1/2"	1/2"	1/2"		DRUM TRAPS FIRST FLOOR
COMBINATION SINK AND TRAY	1/2"	1/2"	1/2"		CONT. WASTE
RANGE				3/4"	
H.W. HEATER	1/2"	1/2"		3/4"	
SPACE HEATERS					FLUE CONNECTIONS

NOTE: RANGES, H.W. HEATERS, & SPACE HEATERS WILL BE FURNISHED BY OTHERS. SEE SPEC.

ELECTRICAL SYMBOLS

- CEILING FIXTURE. SEE SPEC. FOR TYPE OF FIXTURE.
- CEILING FIXTURE WITH PULL CORD SWITCH.
- BRACKET FIXTURE WITH LAMP HOLDER, TOGGLE CONTROL SWITCH AND SINGLE INSERTION RECEPTACLE (5'0" MOUNTING HEIGHT).
- COMBINATION TOGGLE SWITCH AND INSERTION RECEPTACLE.
- DUPLEX INSERTION RECEPTACLE (12" MOUNTING HEIGHT EXCEPT IN KITCHEN WHICH SHALL BE 4'0" OR 4'3" HEIGHT).
- SINGLE POLE TOGGLE WALL SWITCH (4'0" MOUNTING HEIGHT).
- THREE WAY TOGGLE WALL SWITCH.
- COMBINATION INSERTION RECEPTACLE AND SINGLE & THREE WAY TOGGLE SWITCHES.
- WEATHER - PROOF.

SECTION SHOWING TYPICAL
ELECTRIC SERVICE CONNECTIONS
TO EACH BUILDING AND D.U.
SCALE: 3/4" = 1'-0"

SHEET TITLE: **DETAIL UNIT PLANS BUILDINGS 25-26**

GONZALES GARDENS EXTENSION
LOW RENT HOUSING PROJECT, COLUMBIA, SC 21A

THE HOUSING AUTHORITY, CITY OF COLUMBIA, S.C.

DATE: 3/27/42

601