


SECOND FLOOR PLAN  
SCALE: 1/4" = 1'-0"

TYPICAL PLAN:  
6 1/2 ROOM - 4 ROOM COMBINATION

TYPICAL PLAN:  
6 1/2 ROOM - 6 1/2 ROOM COMBINATION

TYPICAL PLAN:  
4 ROOM - 6 1/2 ROOM COMBINATION

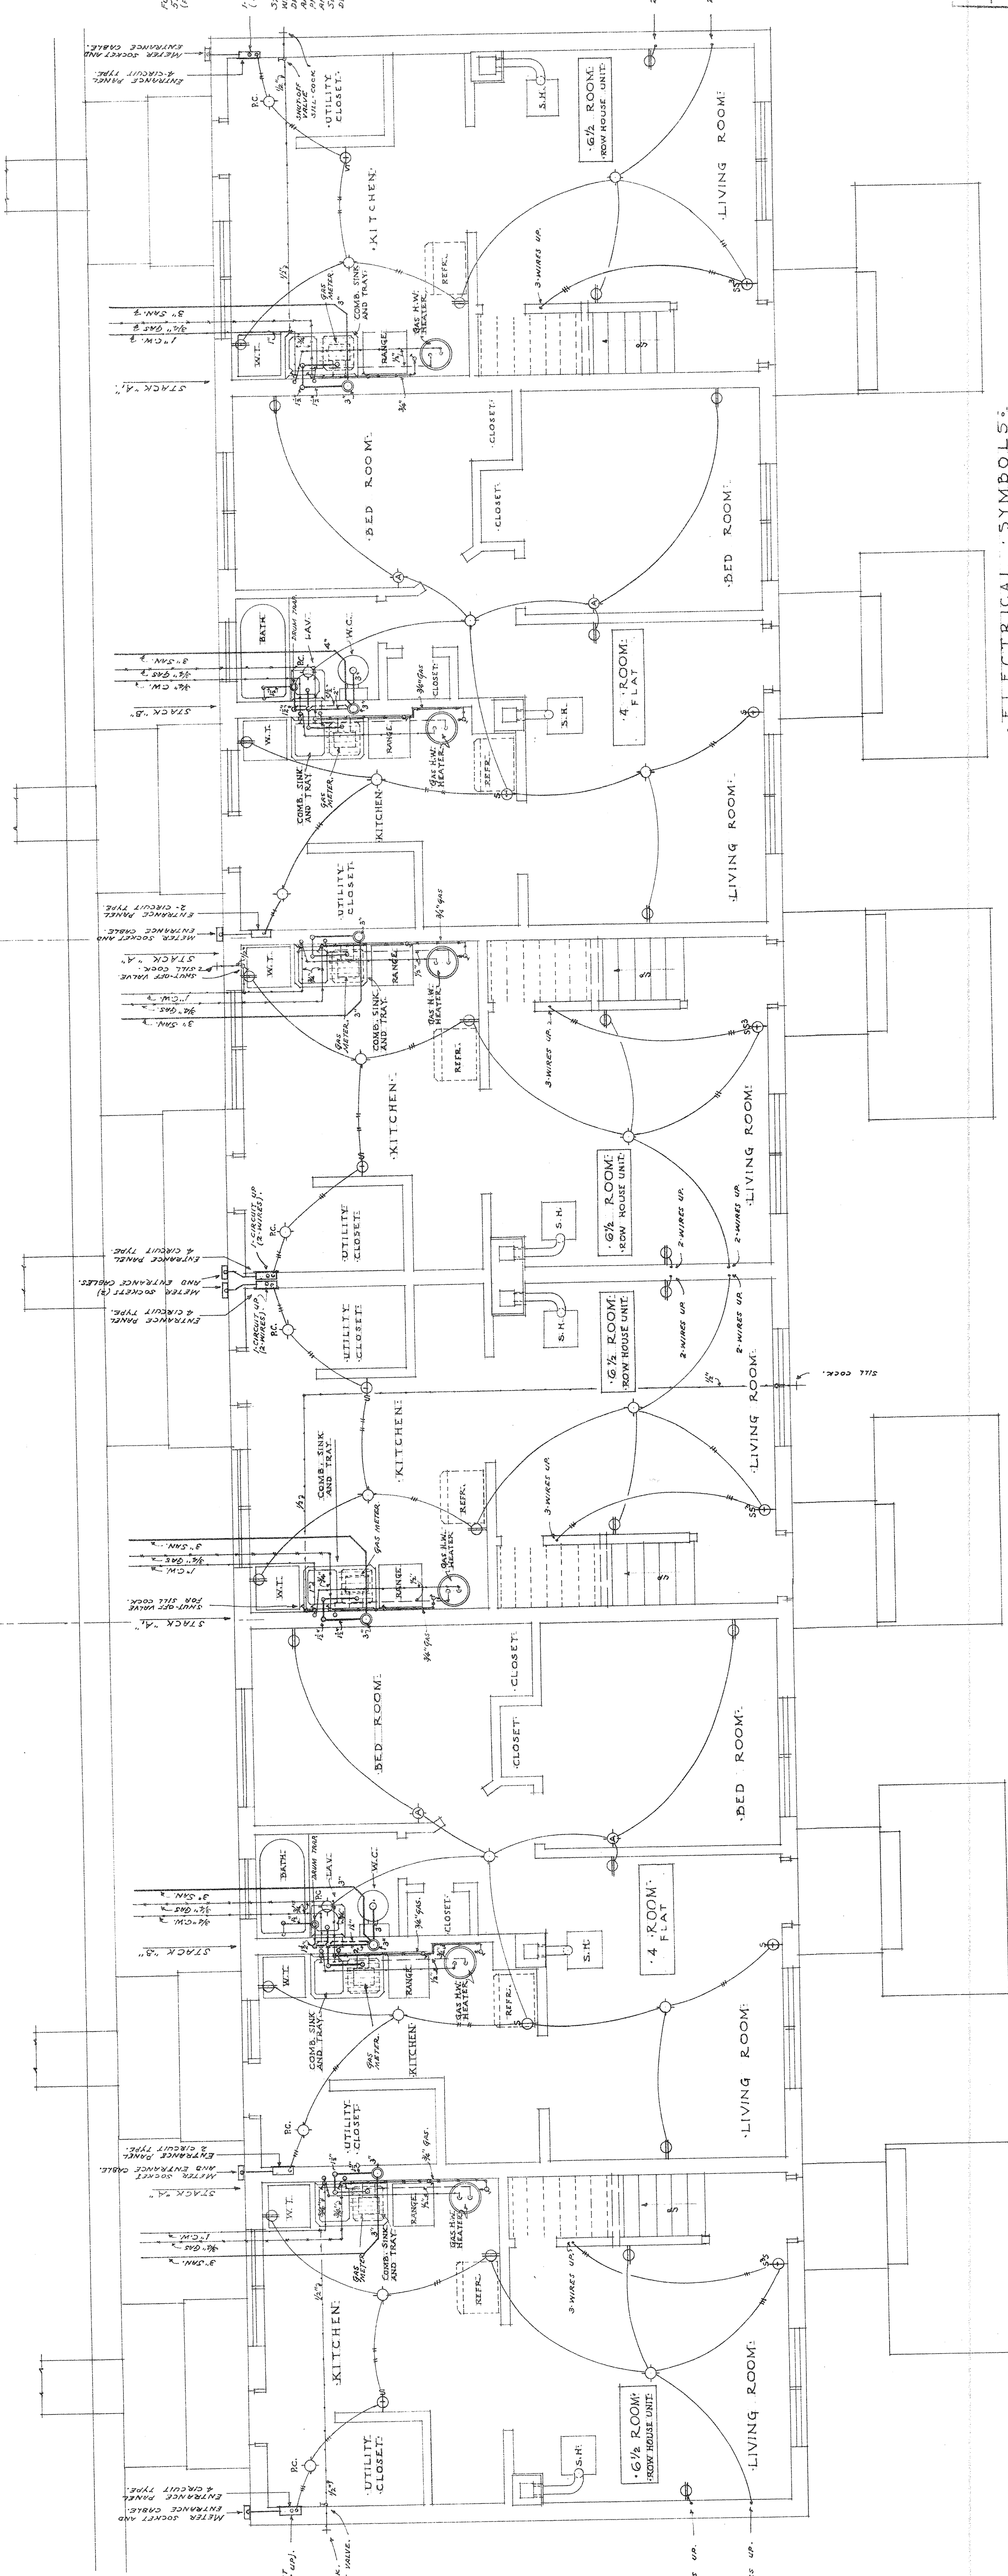

**SCHEDULE OF FIXTURE CONNECTIONS**

TYPE	H.W.	C.W.	TRAP	BAS.	REMARKS
WATER CLOSET	3/4"	3/4"	1/2"		
LAVATORIES	3/4"	3/4"	1/2"		
BATHS	3/4"	3/4"	1/2"		
COMBINATION	3/4"	3/4"	1/2"		
RANGE	3/4"	3/4"	1/2"		
H.W. HEATER	3/4"	3/4"	1/2"		
SPACE HEATER	3/4"	3/4"	1/2"		

NOTE: RANGES, H.W. HEATERS, & SPACE HEATERS WILL BE FURNISHED BY OTHERS.

- ELECTRICAL SYMBOLS:**
- CEILING FIXTURE WITH FULL CORD SWITCH, CONVENIENT FOR TYPE OF FIXTURE.
  - BRACKET AND SINGLE INSERTION RECEPTACLE, (150 MOUNTING HEIGHT).
  - COMBINATION DOUBLE SWITCH AND INSERTION RECEPTACLE, (40" MOUNTING HEIGHT).
  - DUPLEX INSERTION RECEPTACLE, (20 MOUNTING HEIGHT EXCEPT IN KITCHEN WHICH SHALL BE 40"). (40" MOUNTING HEIGHT).
  - SINGLE POLE TOGGLE WALL SWITCH, (40" MOUNTING HEIGHT).
  - THREE WAY TOGGLE WALL SWITCH.
  - WAY TOGGLE SWITCHES.
  - W.P. WEATHER - PROOF.

SECTION SHOWING TYPICAL  
ELECTRIC SERVICE CONNECTIONS  
TO EACH BUILDING AND D.U.

SCALE: 3/4" = 1'-0"

**DETAIL - UNIT PLANS**  
BUILDINGS 25 & 26  
CONVALESCECE EXTENSION  
LOW BENT HOUSE PROJECT, CHICAGO, ILL. 502-1A  
THE ARCHITECT: JAMES F. POSEY  
CONSULTING ENGINEERS

**KEY PLAN**

**601**