


ELECTRICAL NOTES:
1. ALL WIRING TO BE DONE IN ACCORDANCE WITH THE NATIONAL ELECTRICAL CODE, 1933, AS AMENDED.
2. ALL WIRING TO BE DONE IN ACCORDANCE WITH THE NATIONAL ELECTRICAL CODE, 1933, AS AMENDED.
3. ALL WIRING TO BE DONE IN ACCORDANCE WITH THE NATIONAL ELECTRICAL CODE, 1933, AS AMENDED.

SECOND FLOOR PLAN
SCALE: 1/4" = 1'-0"

TYPICAL PLAN: 5 1/2 ROOM - 4 1/2 ROOM COMBINATION
TYPICAL PLAN: 5 1/2 ROOM - 4 1/2 ROOM COMBINATION
TYPICAL PLAN: 5 1/2 ROOM - 4 1/2 ROOM COMBINATION
TYPICAL PLAN: 5 1/2 ROOM - 4 1/2 ROOM COMBINATION

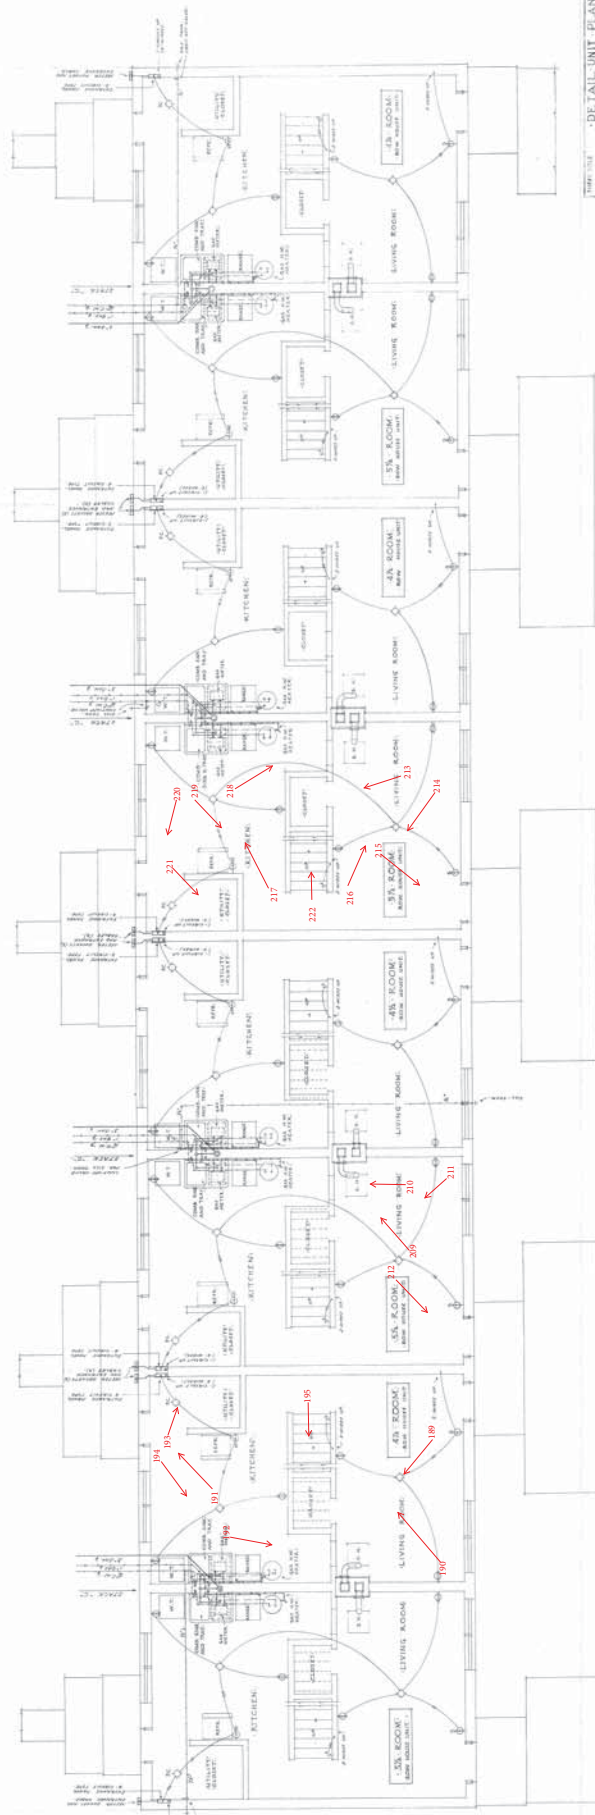

ELECTRICAL NOTES:
1. ALL WIRING TO BE DONE IN ACCORDANCE WITH THE NATIONAL ELECTRICAL CODE, 1933, AS AMENDED.
2. ALL WIRING TO BE DONE IN ACCORDANCE WITH THE NATIONAL ELECTRICAL CODE, 1933, AS AMENDED.
3. ALL WIRING TO BE DONE IN ACCORDANCE WITH THE NATIONAL ELECTRICAL CODE, 1933, AS AMENDED.

FIRST FLOOR PLAN
SCALE: 1/4" = 1'-0"

DETAIL UNIT PLANS
BUILDINGS NOS. 27, 28, 29, 30
CITY OF NEW YORK
DEPARTMENT OF CONSTRUCTION
BUREAU OF BUILDINGS
DIVISION OF BUILDINGS
NEW YORK, N. Y.

KEY PLAN
SCALE: 1/4" = 1'-0"

602