


DETAIL OF OUTSIDE LIGHTING BRACKET FIXTURE
SCALE: 1/8" = 1'-0"

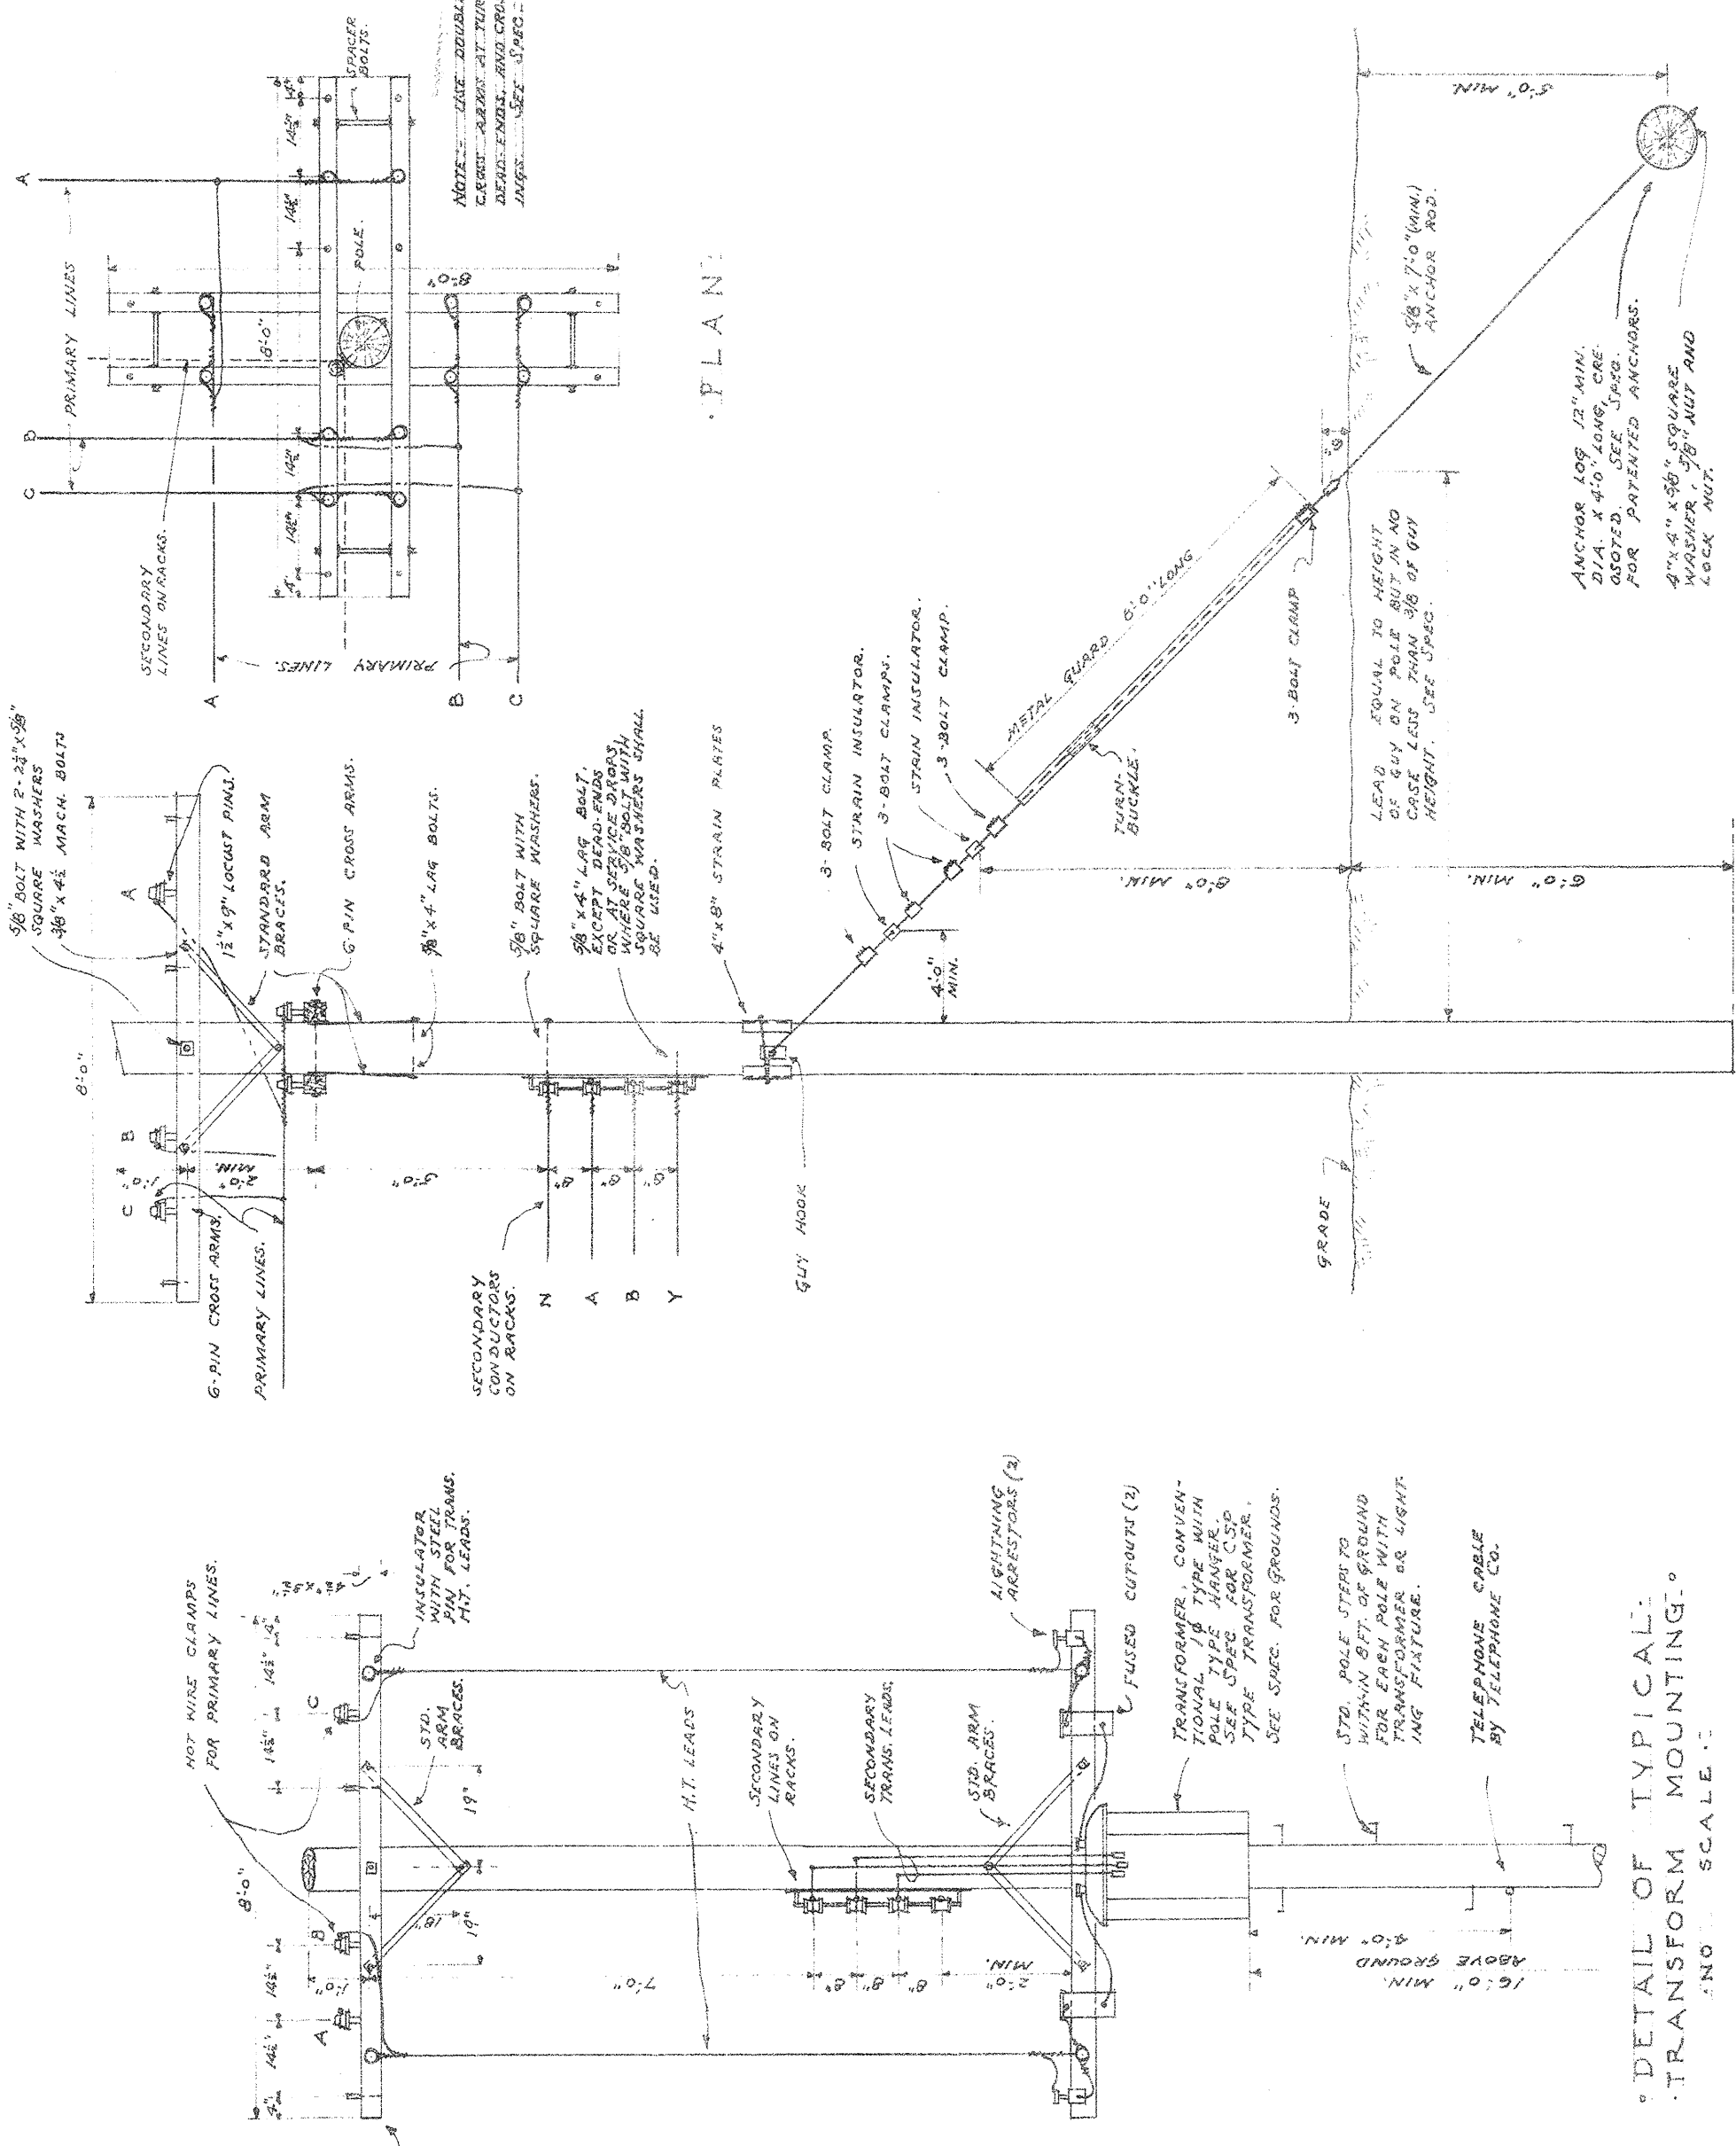


DETAIL OF TYPICAL TURN POINT
IN OVERHEAD DISTRIBUTION LINE
AND TYPICAL GUY & ANCHOR DETAIL
SCALE: 1/8" = 1'-0"


KEY PLAN

PROJECT TITLE
 TYPICAL PLUMBING AND ELECTRICAL DETAILS AND DIAGRAMS
 CONVALES CENTERS EXTENSION
 LOW REEF HOUSING PROJECT COLUMBIA SC21A
 THE HOUSING AUTHORITY OF THE CITY OF COLUMBIA, S.C.
 ARCHITECT: JAMES POSEY CONSULTING ENGINEERS
 DATE: 2-27-72


SHEET NO. **604**
 OF **604**
 DRAWN BY: **W. H. HARRIS**
 CHECKED BY: **J. H. HARRIS**
 DATE: **2-27-72**

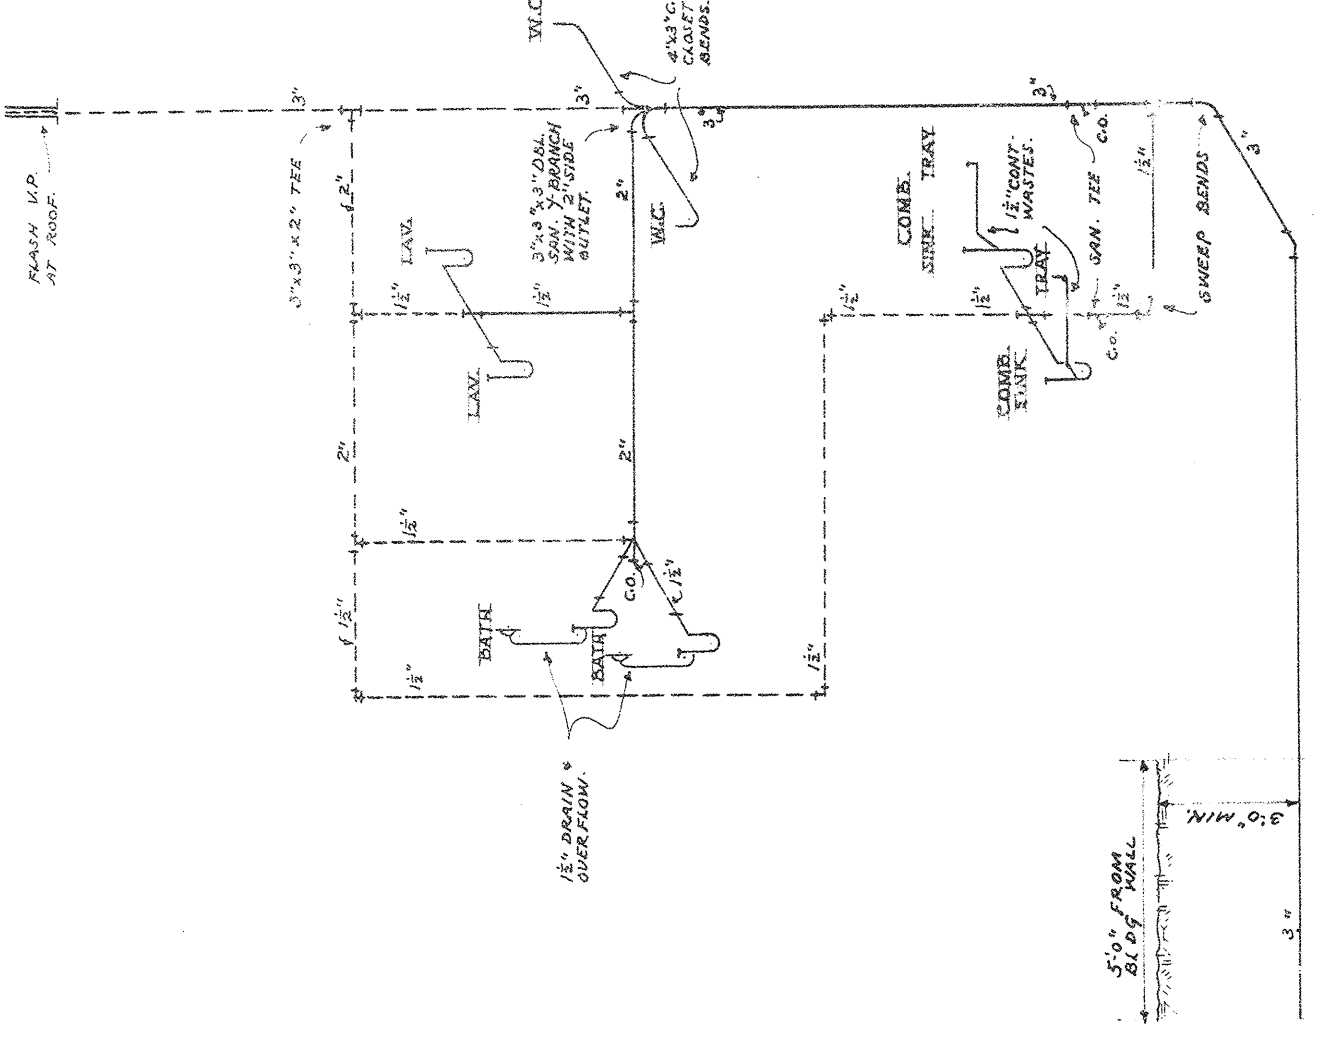


STACK "C"
DIAGRAM OF WASTE, SOIL, AND VENT STACK
SCALE: 3/4" = 1'-0"

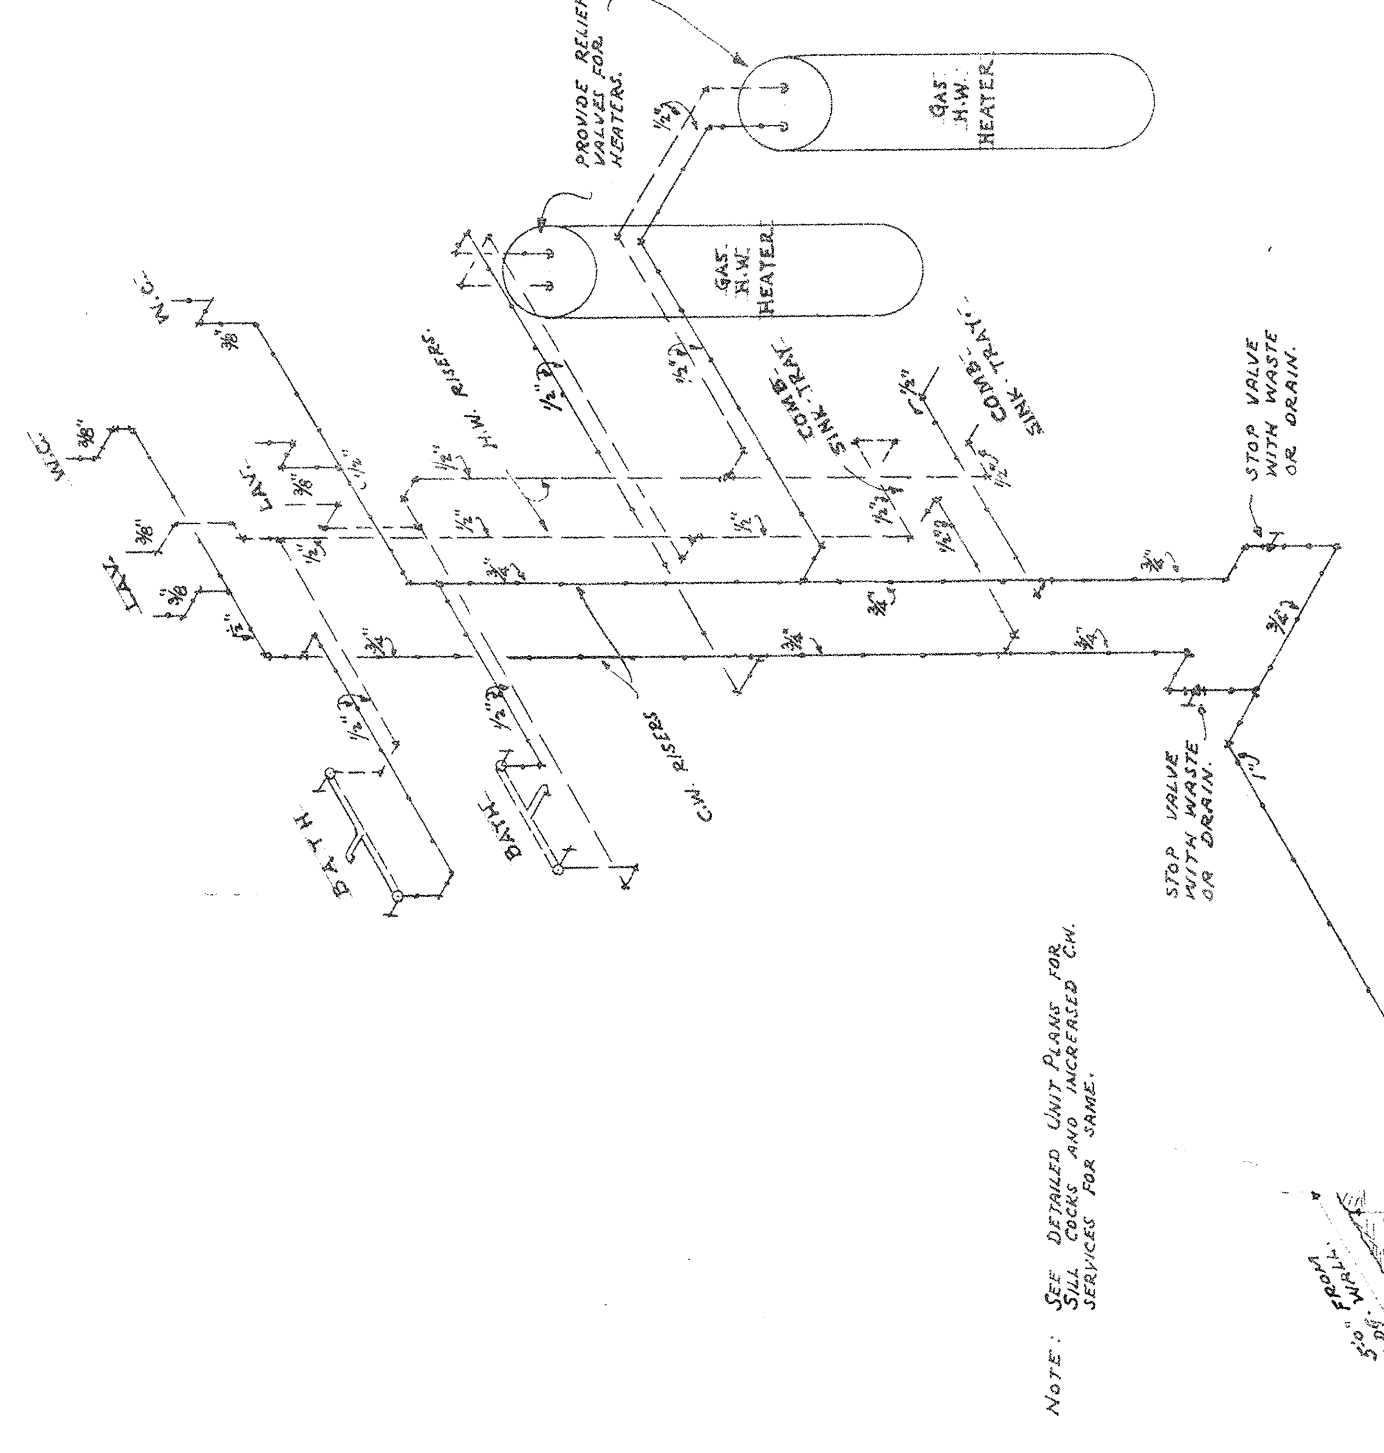


STACK "C"
DIAGRAM OF WATER PIPING
FOR TYPICAL 41 AND 51 ROOM COMBINATIONS
SCALE: 3/4" = 1'-0"

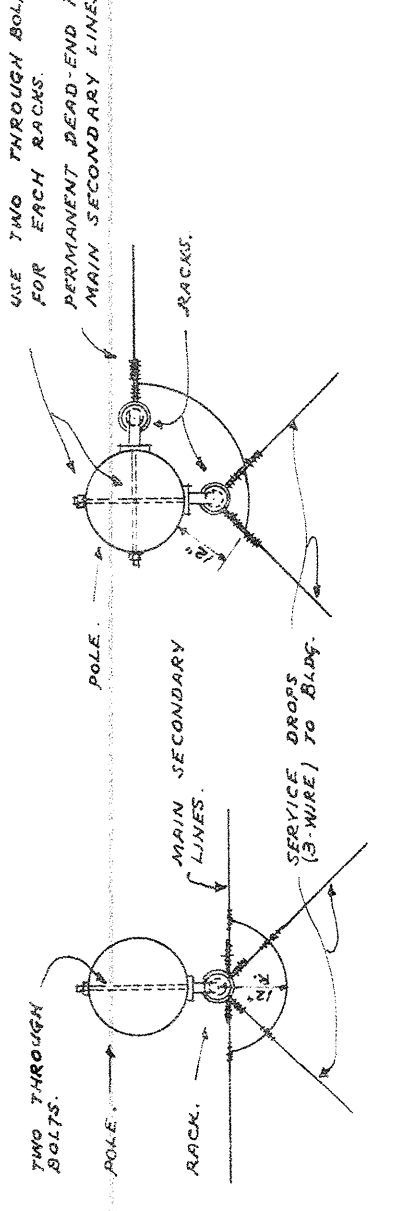


DIAGRAMS SHOWING TYPICAL SECONDARY CONNECTIONS

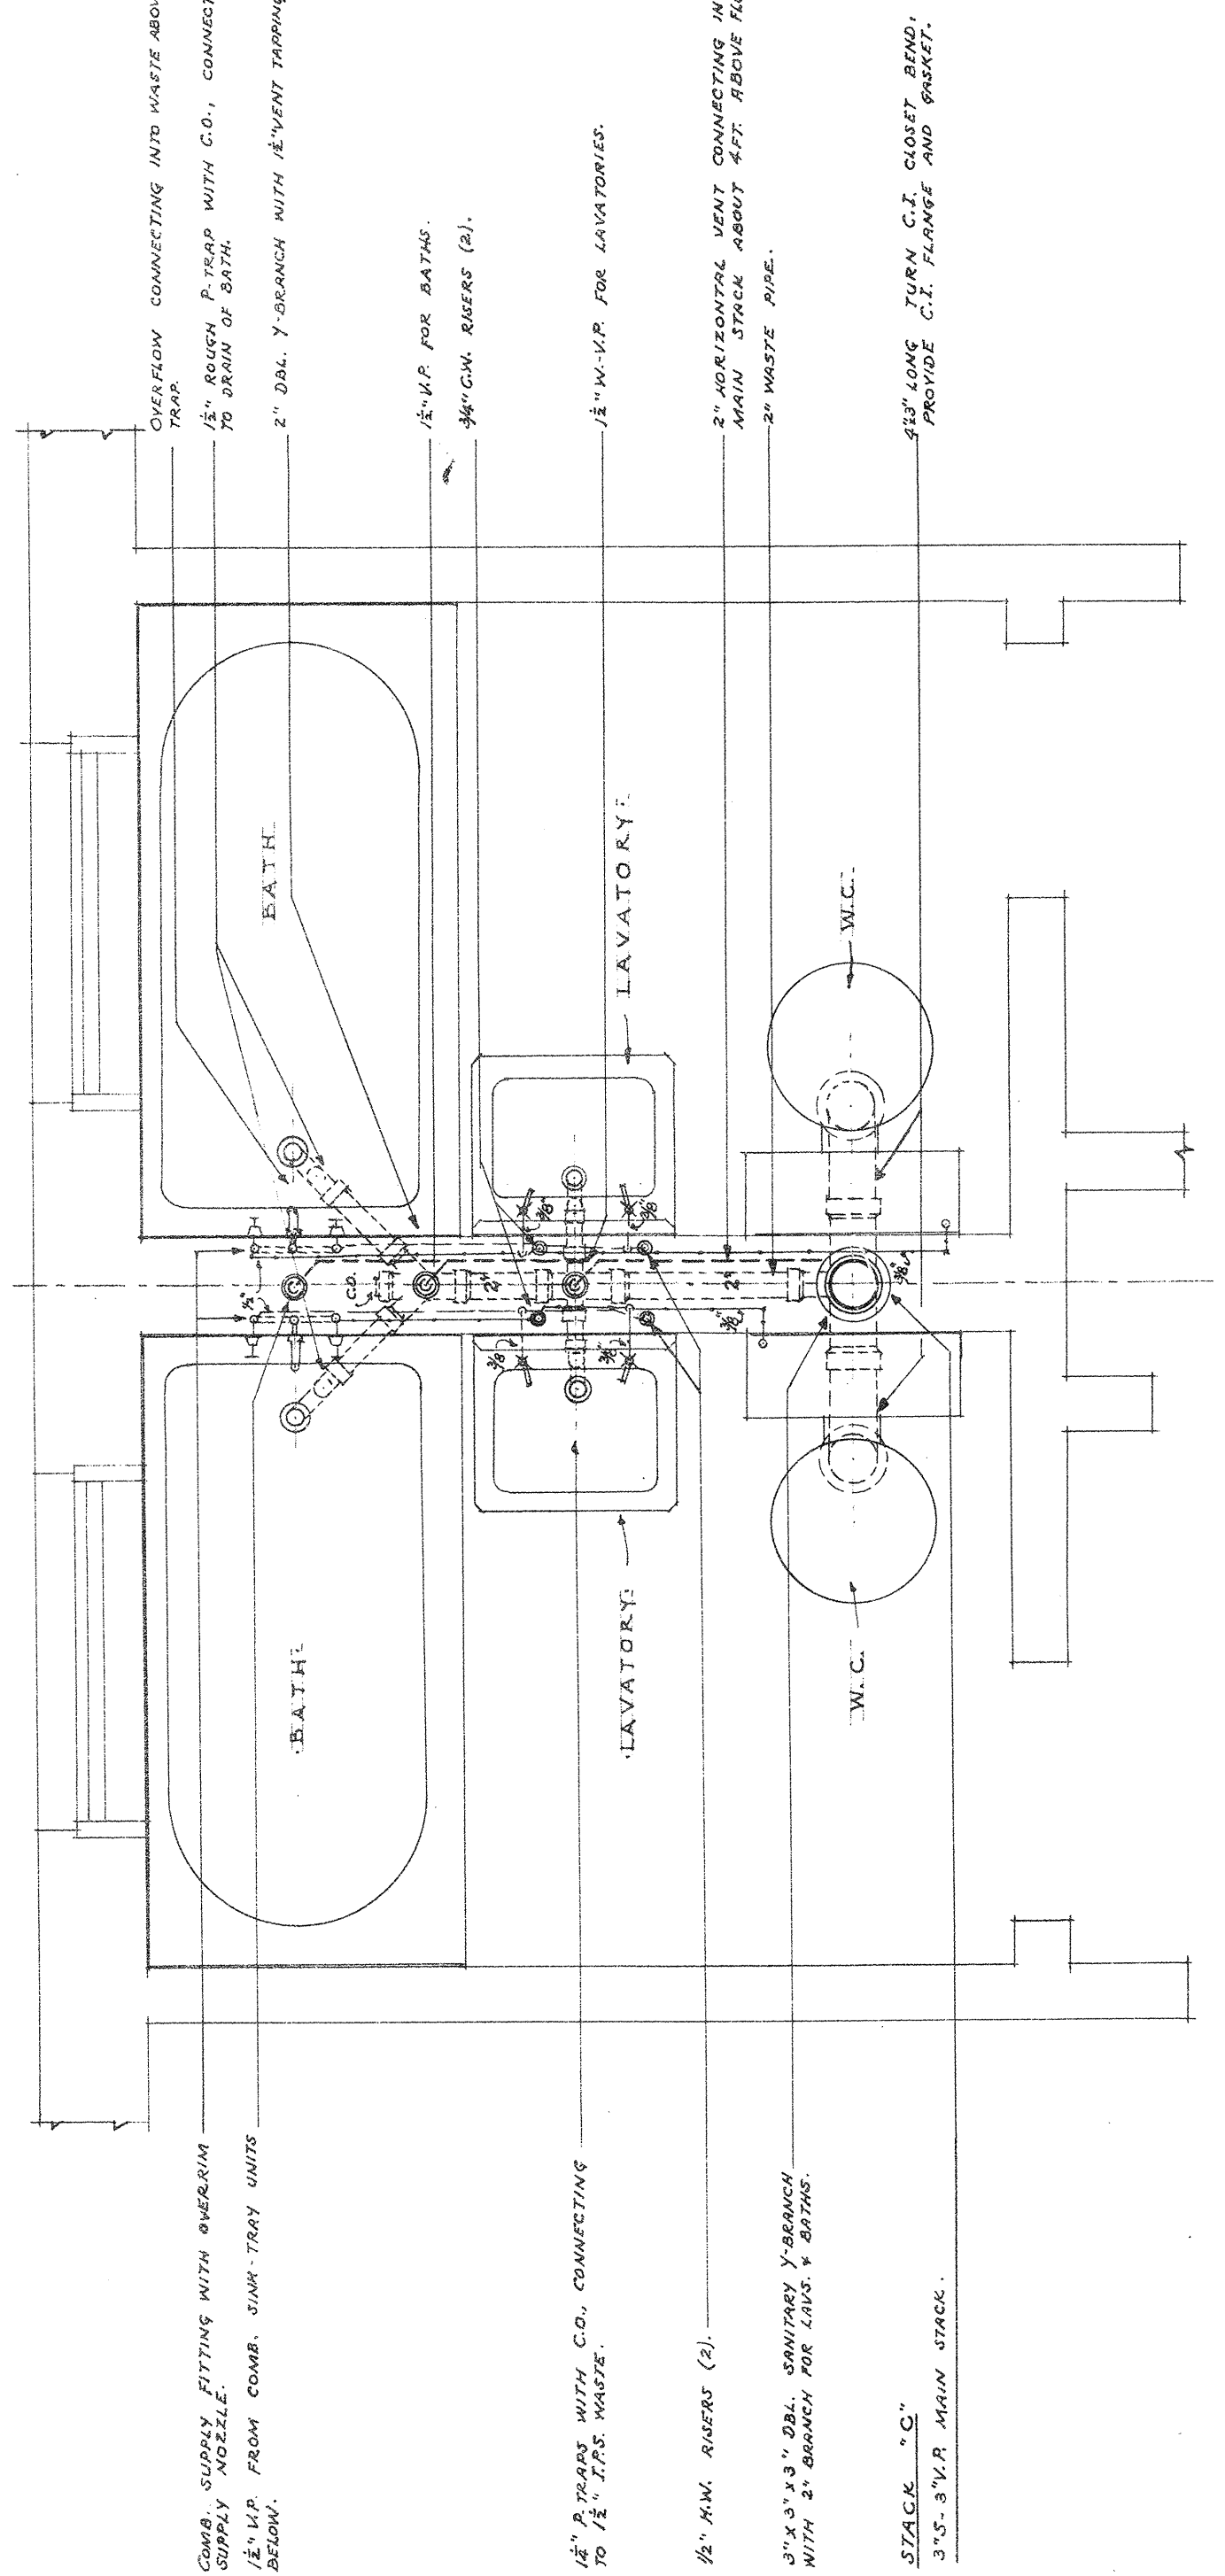

STACK "C"
SECOND FLOOR PLAN
SCALE: 3/4" = 1'-0"

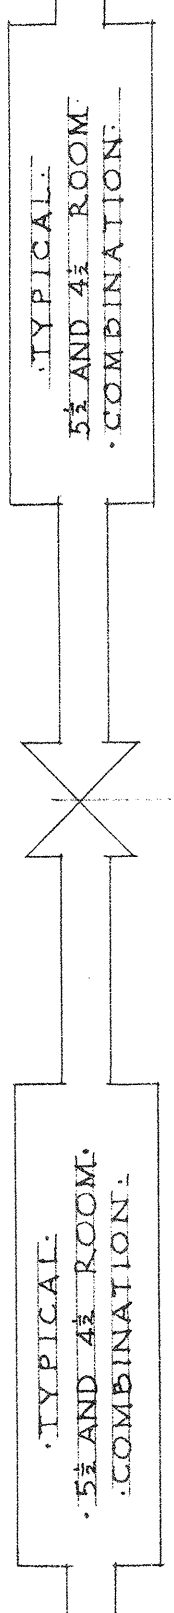

TYPICAL 51 AND 41 ROOM COMBINATION

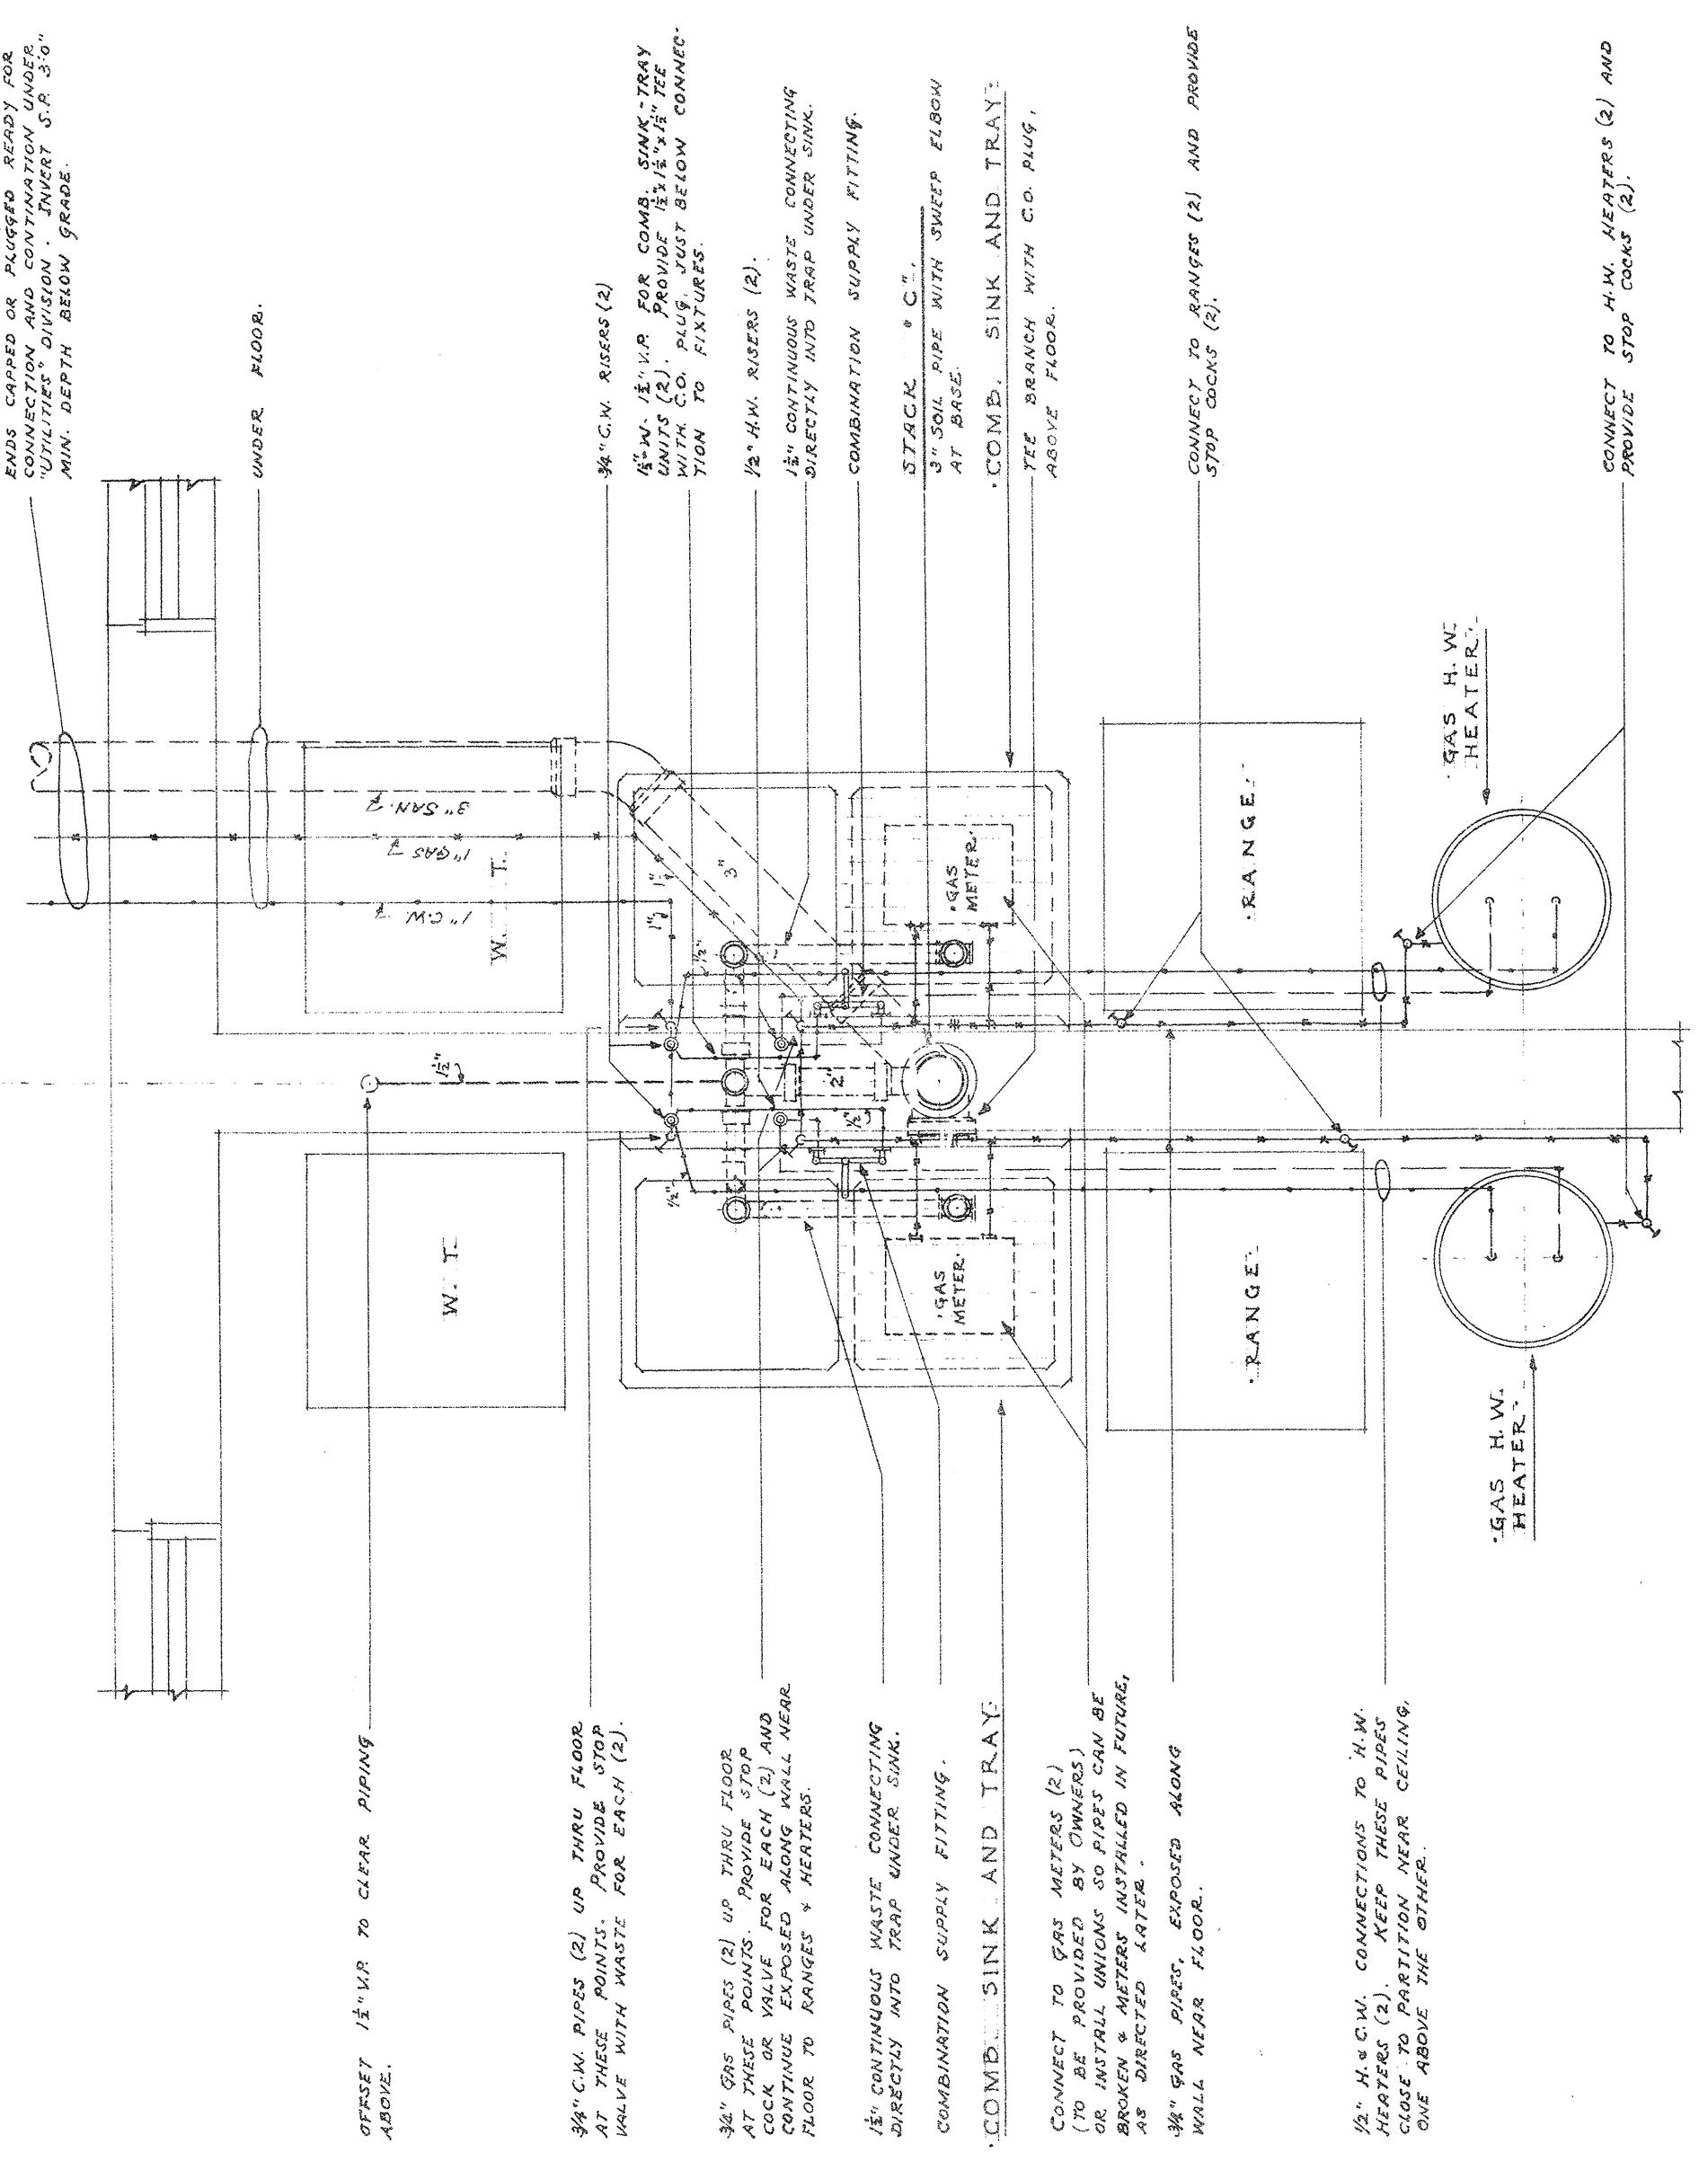

STACK "C"
FIRST FLOOR PLAN
SCALE: 3/4" = 1'-0"

SEE ARCHITECTURAL WORK FOR EXACT LOCATIONS OF FIXTURES AND EQUIPMENT IN KITCHENS AND BATH ROOMS.