


ELECTRICAL NOTES:
SEE SITE PLAN OF ELECTRICAL DIST.
SUBSTATION FOR SERVICE DROP TO EACH
BUILDING AND POINT OF ATTACHMENT.


SECOND FLOOR PLAN
SCALE - 1/4" = 1'-0"

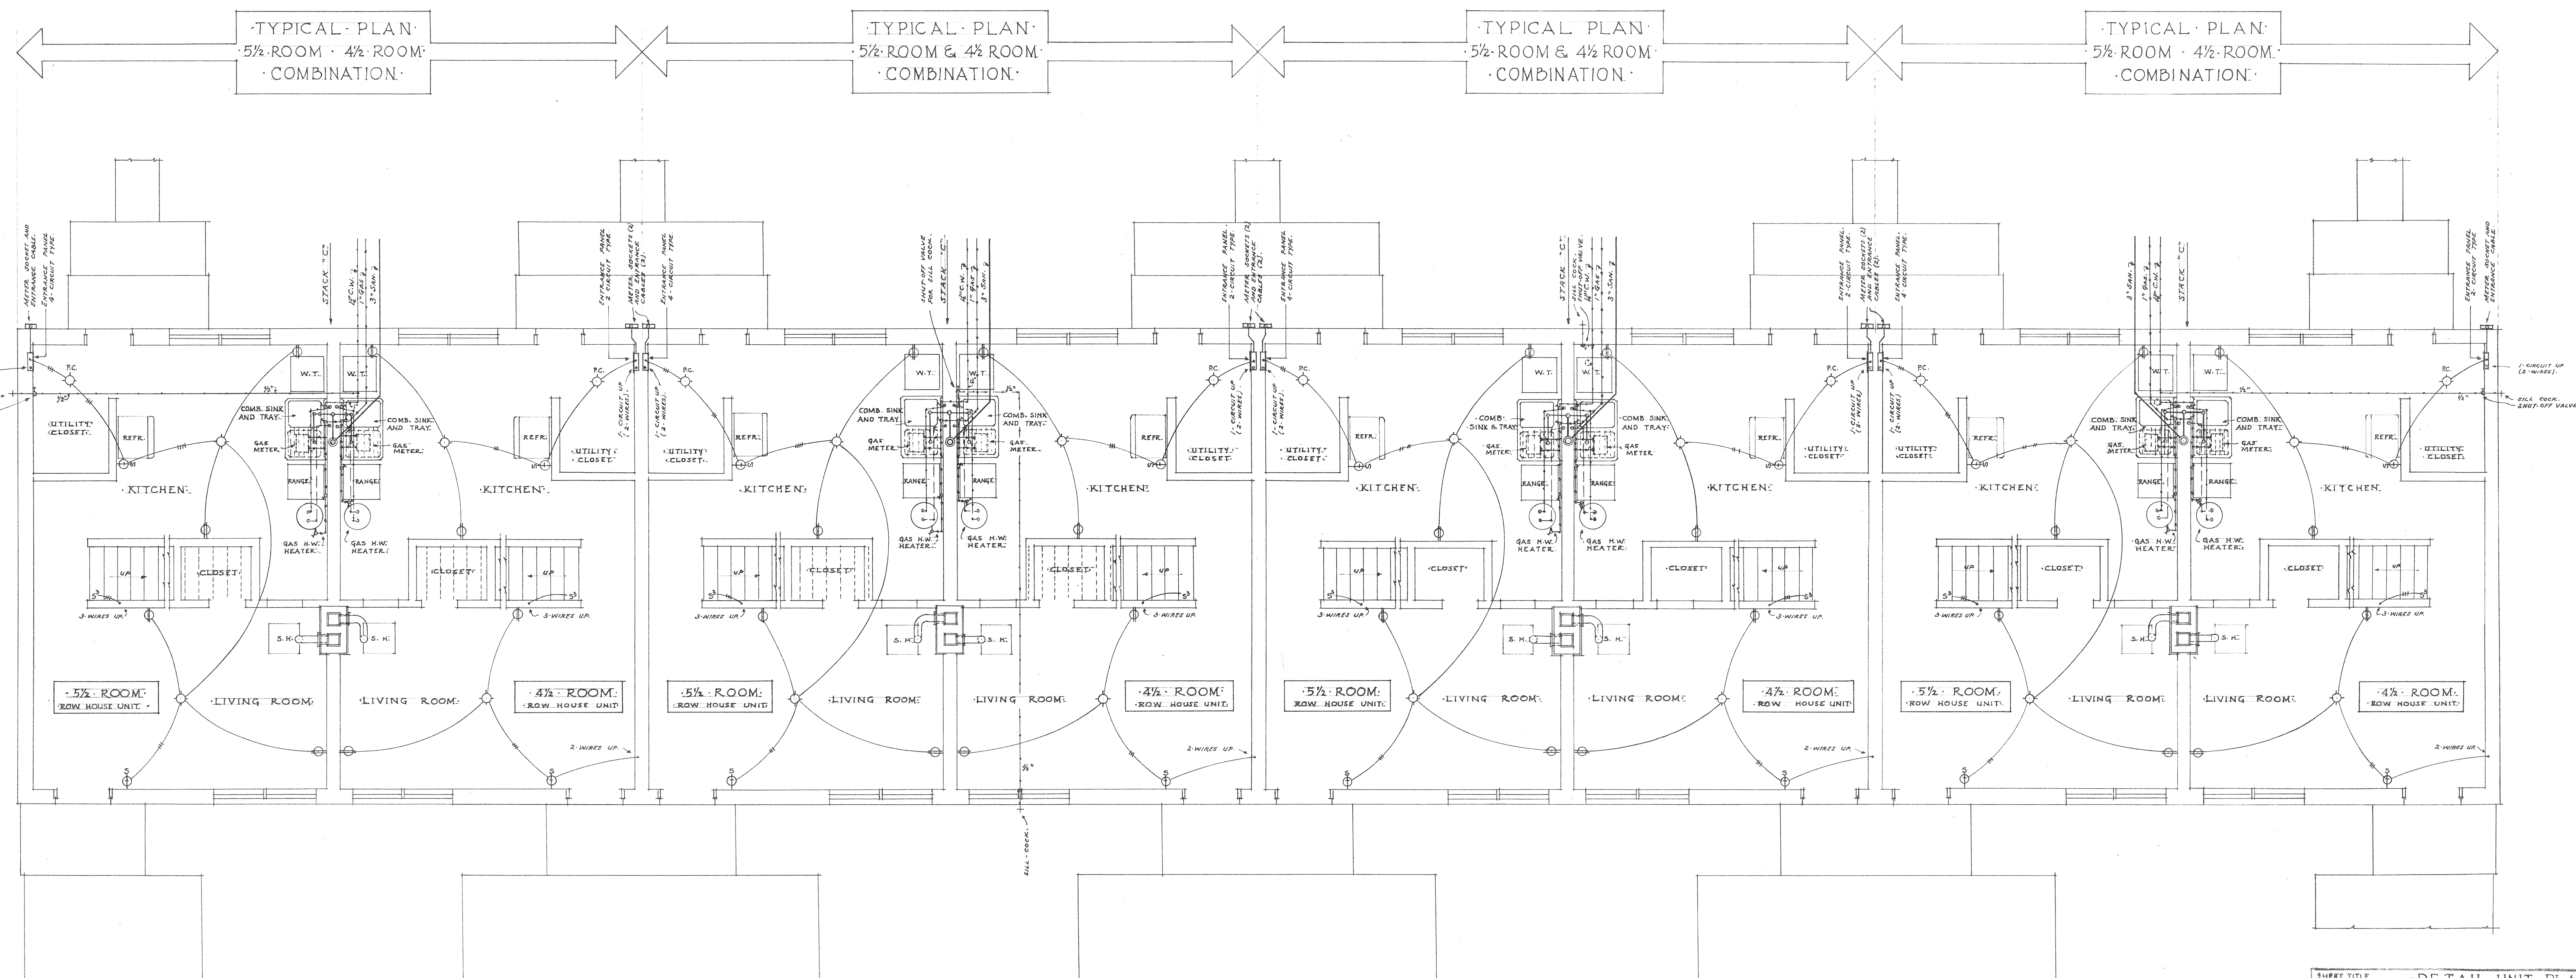

NOTE: SEE 1/4" SCALE DETAILED DRAWINGS
SHOWING TYPICAL PLUMBING DETAIL OF 4 1/2'
AND 5 1/2' ROOM ROW HOUSE UNITS.

FIRST FLOOR PLAN
SCALE - 1/4" = 1'-0"

OFFICE OF
JAMES ROSEY
CONSULTING ENGINEERS

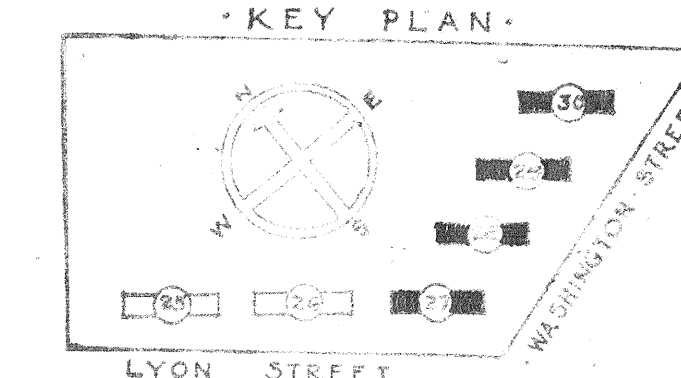

SHEET TITLE		DETAILED UNIT PLANS BUILDINGS - NOS. 27-28-29-30	
CORPUSCLES GARDENS EXTENSION LOW RENT HOUSING PROJECT, COLUMBIA, S.C.		DEVELOPED BY THE HOUSING AUTHORITY OF THE CITY OF COLUMBIA, S.C.	
APPROVED BY JAMES B. ROSEY CONSULTING ENGINEERS		DATE JULY 1934	
SHEET NO. 602		SCALE 1/4" = 1'-0"	