

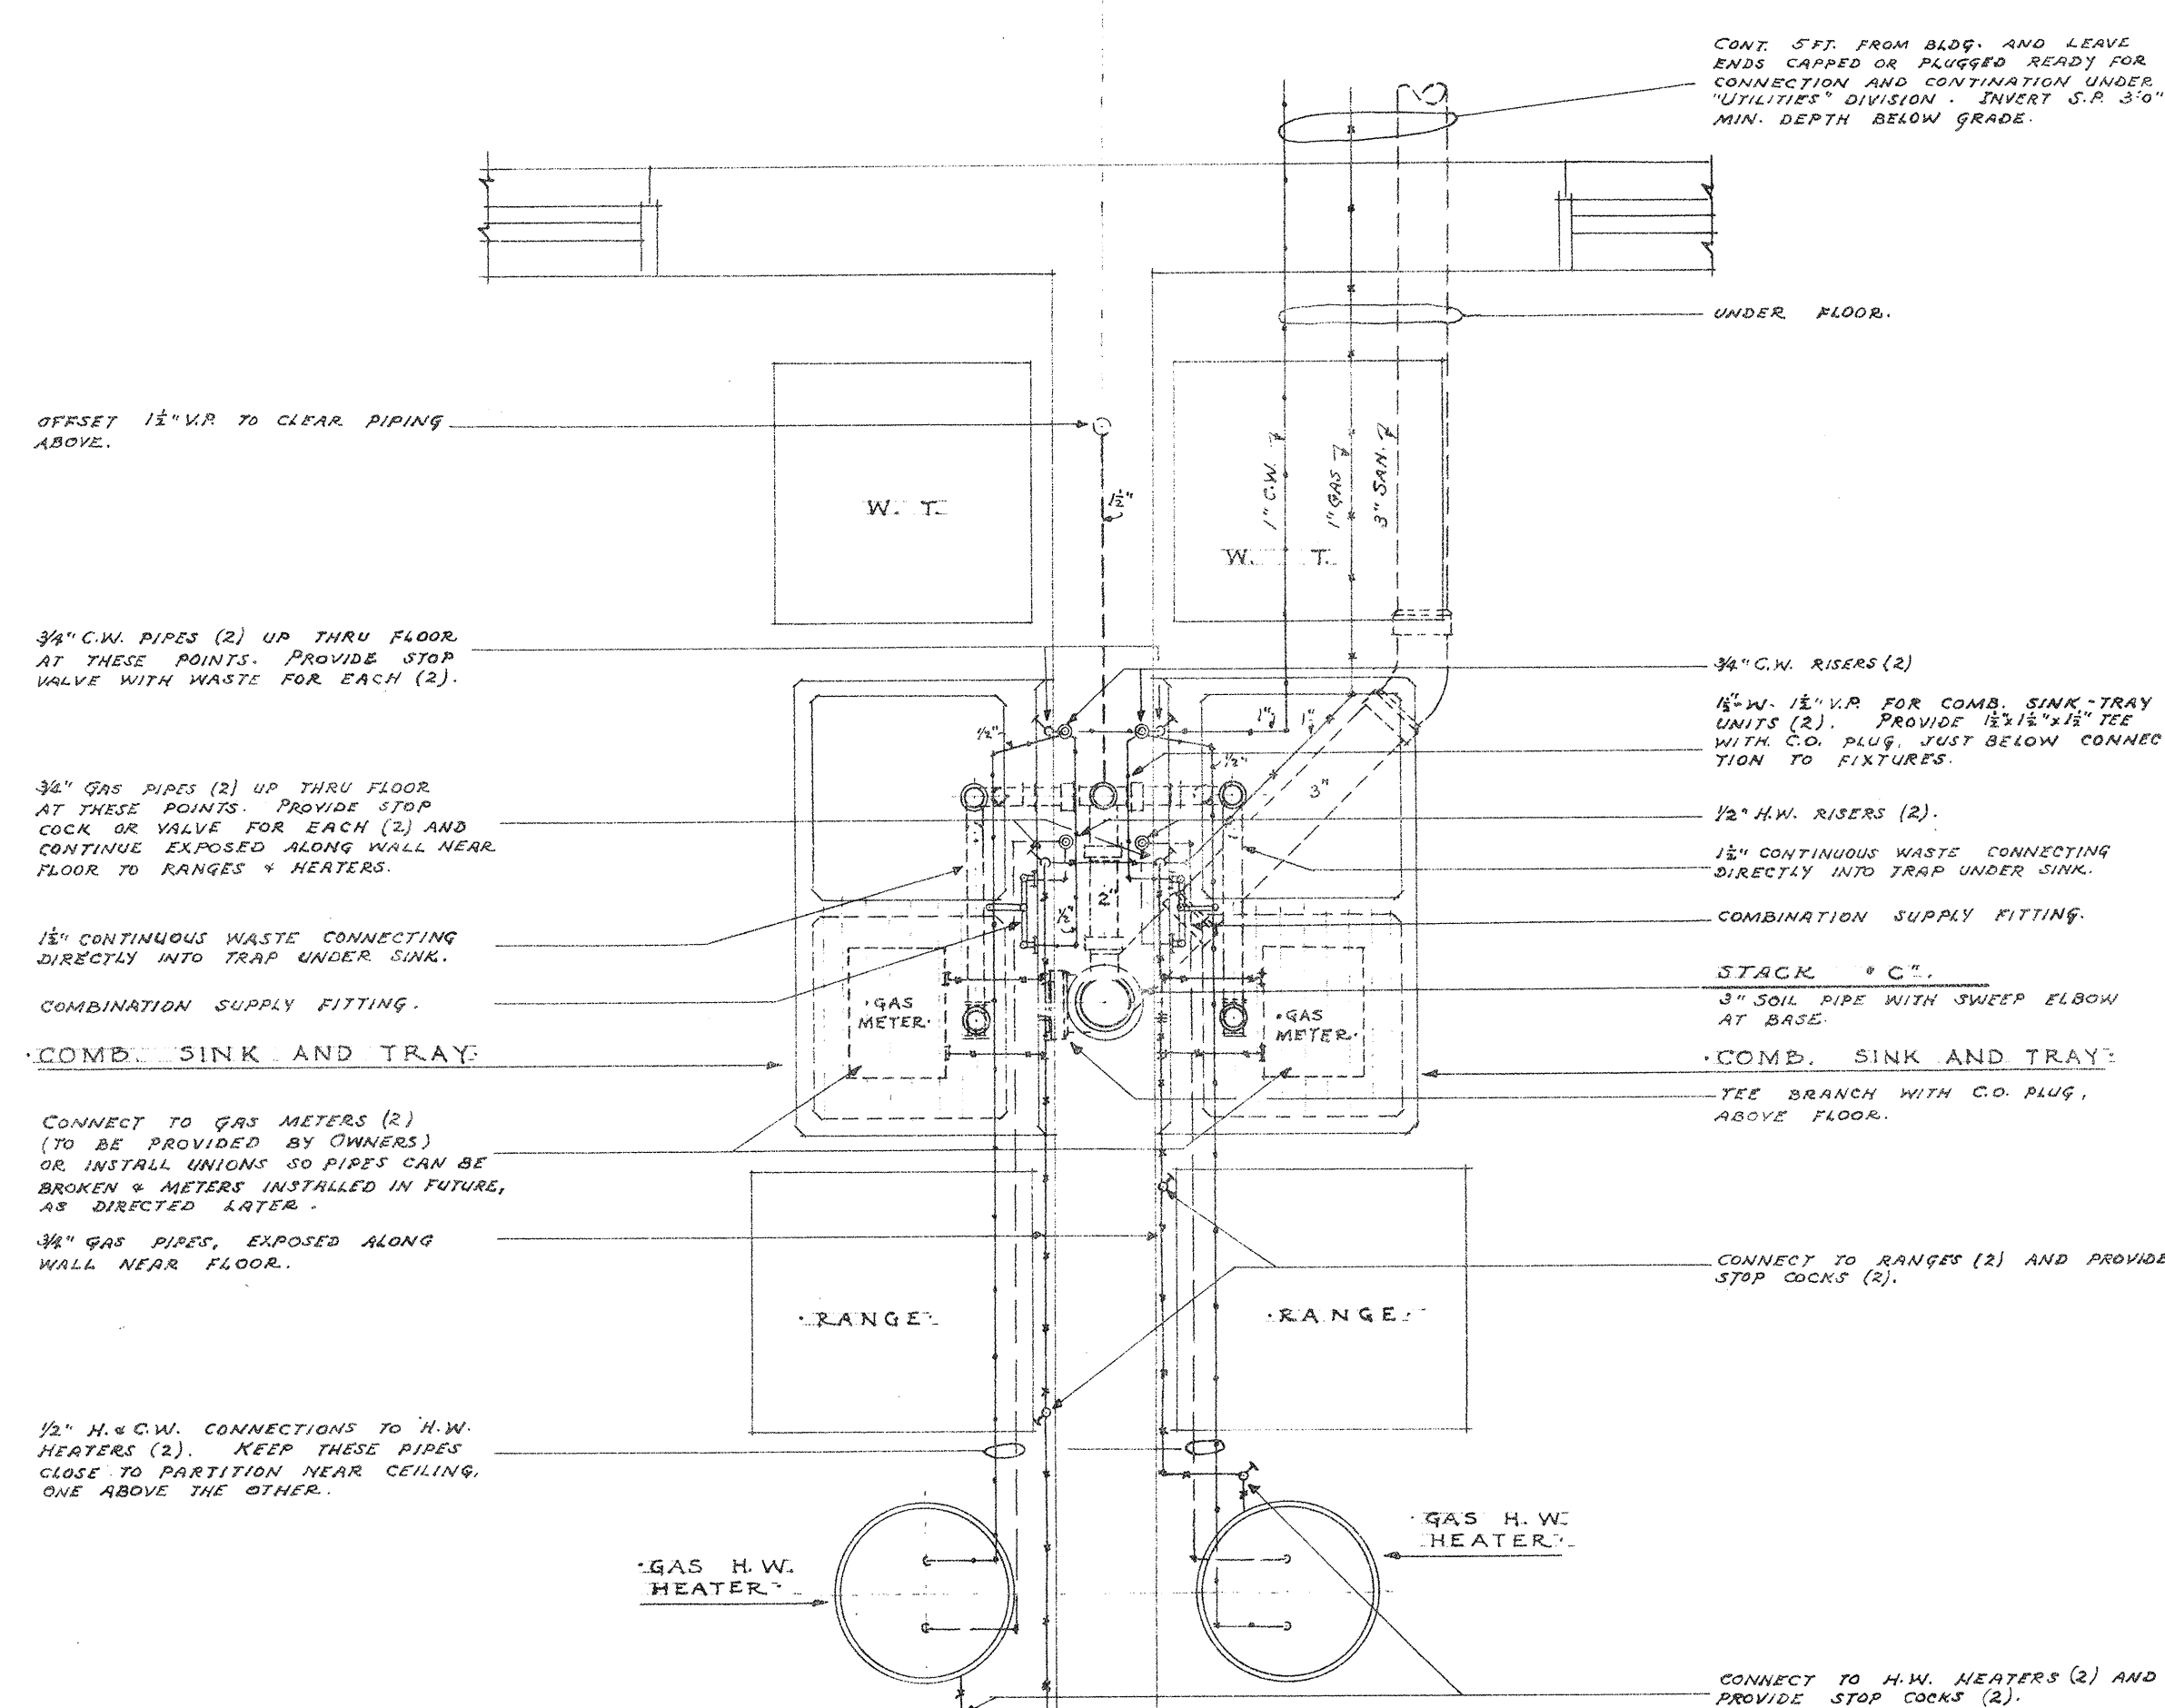
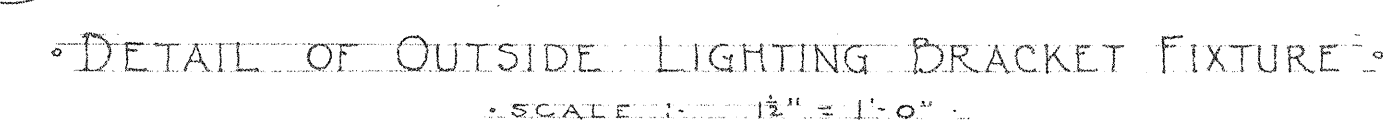
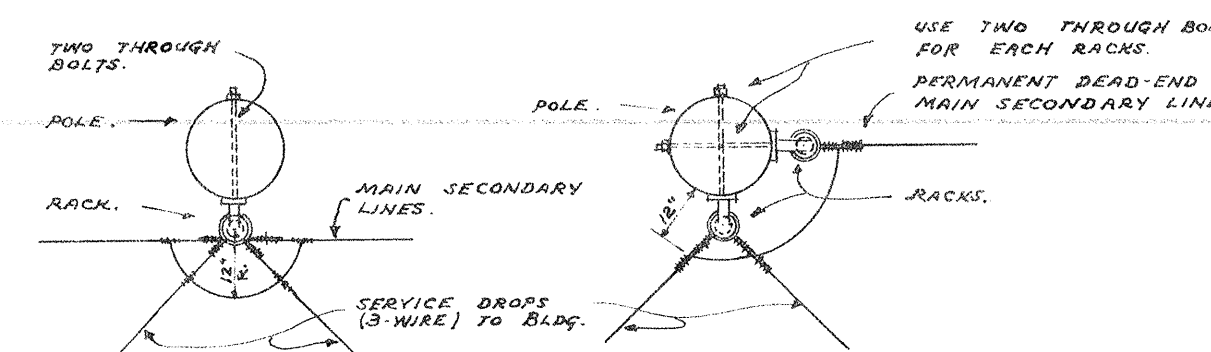


• STACK "C" •  
• DIAGRAM OF WASTE, SOIL  
• AND VENT STACK •

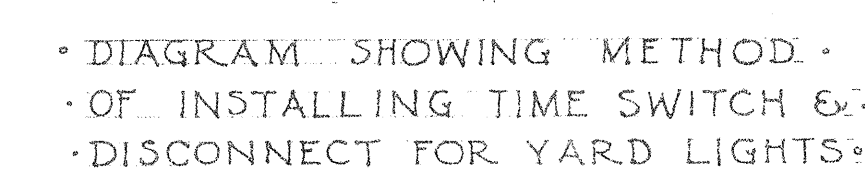


STACK "C".  
FIRST FLOOR PLAN.  
SCALE:  $\frac{3}{4}" = 1'-0"$

• STACK "C".  
• DIAGRAM OF WATER PIPING:  
• FOR TYPICAL 4½ AND 5½ ROOM COMBINATIONS:

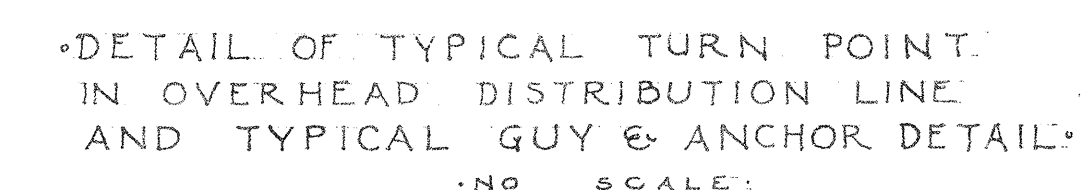

- DIAGRAMS SHOWING TYPICAL SECONDARY CONNECTIONS.

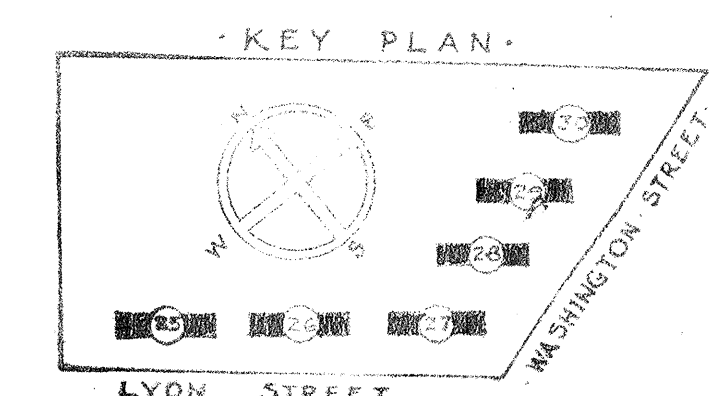

LYON STREET SHEET TITLE		TYPICAL PLUMBING AND ELECTRICAL DETAILS & DIAGRAM	
POTENTIAL OFFENSE EXTENSION LOW RENT HOUSING PROJECT COLUMBIA S.C. 1A THE HOUSING AUTHORITY OF THE CITY OF COLUMBIA, S. C. (USE CITY PROJECT ADDRESS) FEDERAL PUBLIC HOUSING AUTHORITY		SCALES:	
CHECKED:	APPROVED BY:	AS - NOTE	
DATE:	EXPIRATION DATE:	SHEET NO.	
REVISIONS:	APPROVED BY THE HOUSING AUTHORITY OF THE CITY OF COLUMBIA, S.C. <i>copy for 1/2</i>		M
CHAIRMAN: JAMES W. HENRYHART COLUMBIA, S. C.		604	
ARCHITECT: <i>Jos. B. ...</i>		DATE:	