


LEGEND
FOR SITE PLAN

- PRIMARY POLE LINE, OVERHEAD ON CROSS ARMS
- SECONDARY POLE LINE, OVERHEAD ON RACKS
- SECONDARY YARD LIGHTING LINE, OVERHEAD ON RACKS (CONTROLLED BY TIME SWITCHES)
- SECONDARY YARD LIGHTING LINE, PARKWAY CABLE UNDERGROUND (CONTROLLED BY TIME SWITCHES)
- EXISTING OVERHEAD POLE LINE (ELECTRIC, TELEPHONE, OR COMBINED - AS NOTED)
- EXISTING OVERHEAD POLE LINE TO BE REMOVED
- LIGHTING STANDARD, 200 WATT (CONTROLLED BY TIME SWITCH)
- BRACKET LIGHT ON POLE, 150 WATT (CONTROLLED BY TIME SWITCH)
- GUY FOR POLE WITH RACKS
- TRANSFORMER ON POLE

NOTES:
ALL POLES SHALL BE COMBINATION TYPE POLES SO THAT TELEPHONE CO. CAN RUN TELEPHONE CABLE FOR SERVICE TO ADMINISTRATION BUILDING AND TO OTHER BUILDINGS AS MAY BE REQUIRED.
THE EXACT LOCATION OF ALL POLES, GUYS, STANDARDS, AND BRACKET LIGHTS SHALL BE DETERMINED LATER ON THE PREMISES AND MUST BE APPROVED BY THE ARCHITECT.
IN GENERAL, POLES SHALL BE PLACED TO CLEAR WALKS 3 FEET.
CONDUITORS MAY RUN A SINGLE PIPE CONDUITOR FOR YARD LIGHTING, IN CASE OF THE 3 WIRE WORKED ON THE SITE PLAN, AND USE THE REGULAR SECONDARY NEUTRAL IN WHICH CASE A WIRE RACKS SHALL BE USED WITH THE YARD LIGHTING WIRE AT THE BOTTOM AND OF COURSE THE NEUTRAL AT THE TOP.

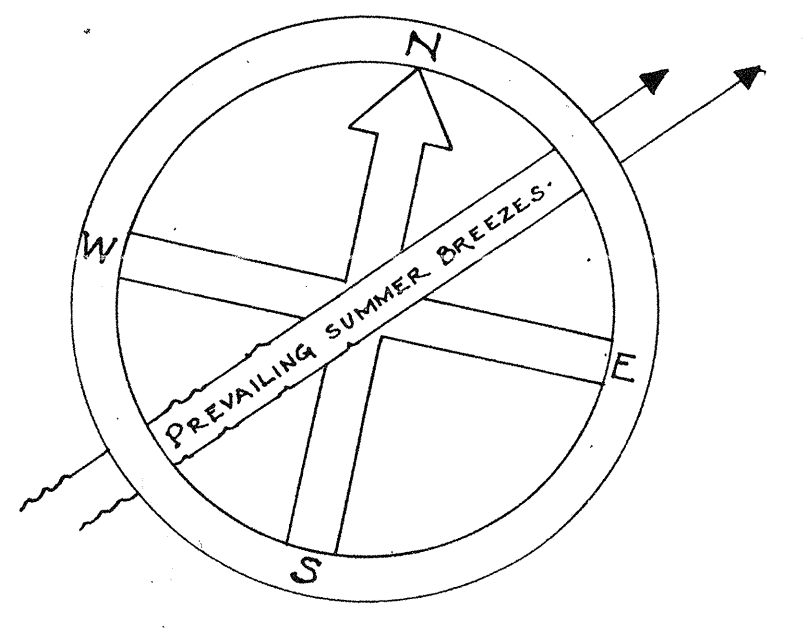

GRAPHIC SCALE
SCALE: 1/40" = 1'-0"

OFFICE OF
JAMES POSEY
CONSULTING ENGINEER

SHEET TITLE		SITE PLAN	
ELECTRICAL DISTRIBUTION			
GONZALES GARDENS			
LOW RENT HOUSING PROJECT, COLUMBIA, S. C. 21			
DEVELOPED BY THE HOUSING AUTHORITY OF THE CITY OF COLUMBIA, S. C.			
UNDER LOAN CONTRACT WITH UNITED STATES HOUSING AUTHORITY			
CHECKED BY C. D. T.	APPROVED BY UNITED STATES HOUSING AUTHORITY	SCALE 1" = 40' FEET	SHEET NO. 607
DATE 9-18-39	ADMINISTRATOR DATE	DATE 9-18-39	
REVISIONS:	APPROVED BY THE HOUSING AUTHORITY OF THE CITY OF COLUMBIA, S. C.	DATE 9-18-39	
	CHAIRMAN JAMES B. LINDHART	DATE 9-18-39	
	ARCHITECT JAMES POSEY	DATE 9-18-39	