
 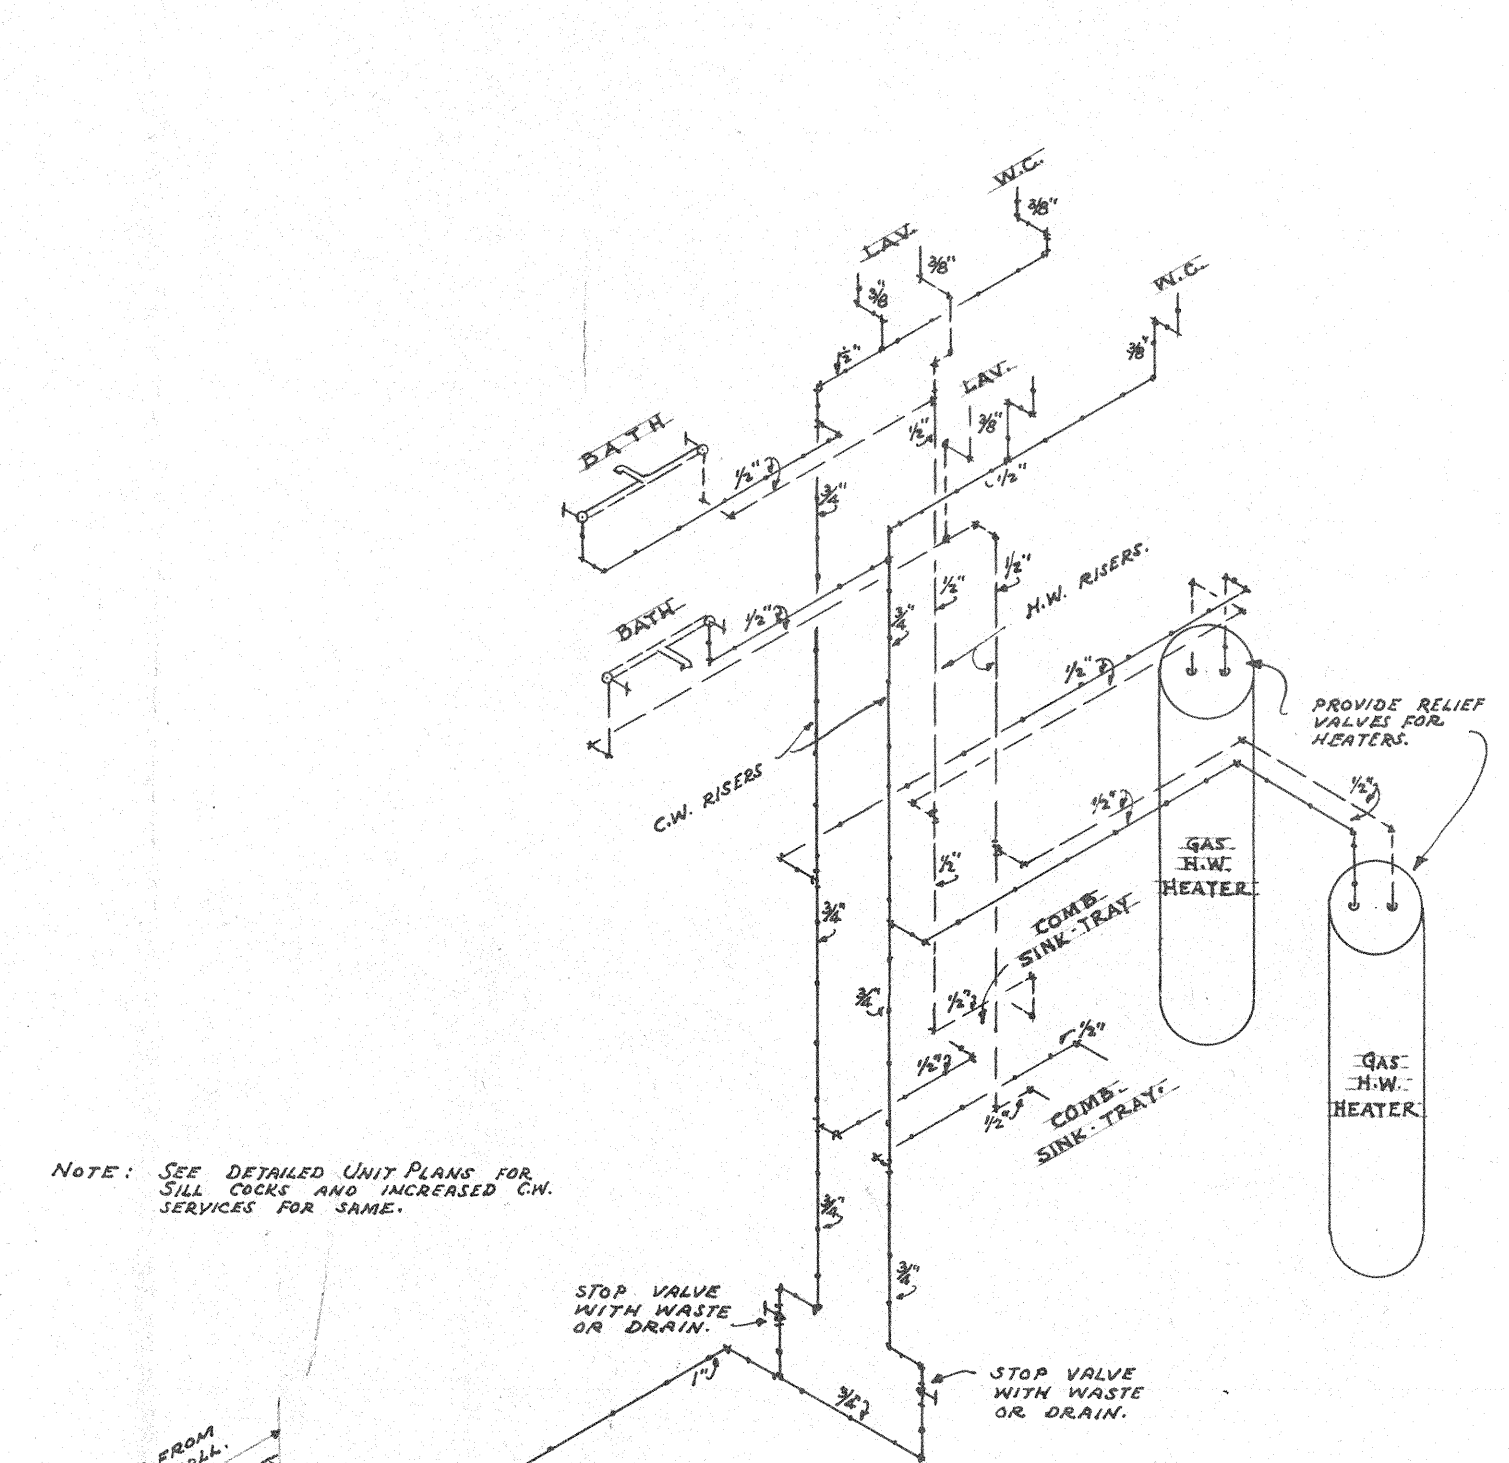


STACK "C":
SECOND FLOOR PLAN
SCALE $\frac{3}{4}" = 1'-0"$



STACK "C".
FIRST FLOOR PLAN.
SCALE: $\frac{3}{4}" = 1'-0"$

DETAIL OF TYPICAL TRANSFORM MOUNTING.

NO SCALE.

SHEET TITLE		TYPICAL PLUMBING AND ELECTRICAL DETAILS & DIAGRAMS	
GONZALES GARDENS EXTENSION			
LOW RENT HOUSING PROJECT, COLUMBIA, SC-21A			
THE HOUSING AUTHORITY OF THE CITY OF COLUMBIA, S. C.			
UNDER LONG CONTRACT AVE.			
FEDERAL PUBLIC HOUSING AUTHORITY			
PREPARED:	APPROVED BY	SCALES:	
		A5 - NOTES	
	ADMINISTRATOR	DATE	
REVISIONS:	APPROVED BY		
	THE HOUSING AUTHORITY OF THE CITY OF COLUMBIA, S. C.		
	DATE		
	CHAIRMAN		
	JAMES W. HIGHTCHART		
	AUGUST COLUMBIA, S. C.		
	ARCHITECT	DATE	